


METAL BASE ON PAVING - ENLARGED PLAN & ELEVATION
1/2" = 1'-0"



METAL BASE ON LAWN - ENLARGED PLAN & SECTION
1/2" = 1'-0"

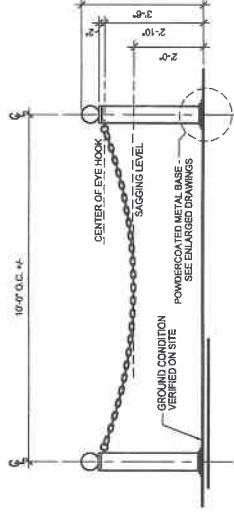

TYPICAL MOVEABLE METAL BOLLARD ON LAWN / ON PAVING - SECTION / ELEVATION
1/2" = 1'-0"



EXISTING BOLLARD

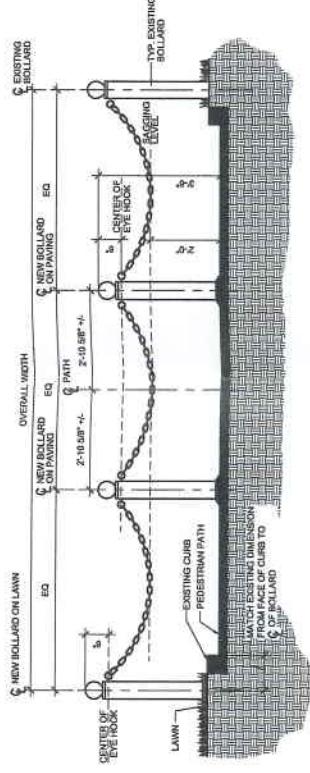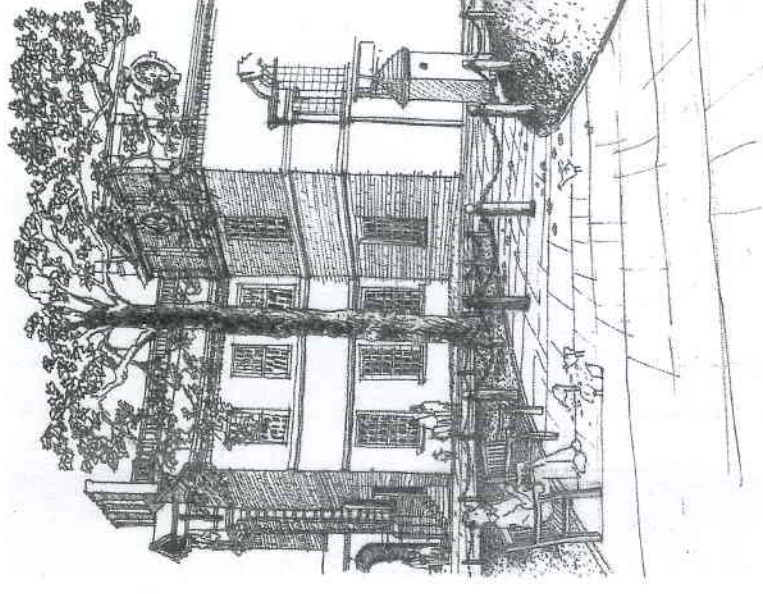

BOLLARDS AT PEDESTRIAN PATHS - ELEVATION
1/2" = 1'-0"



PERSPECTIVES

DRAFT #13

INDEPENDENCE SQUARE SECURITY PLAN
INDEPENDENCE NATIONAL HISTORICAL PARK
WORLD HERITAGE SITE

DESIGNED BY	LA2.00	TITLE OF SHEET	SECURITY BOLLARD DETAILS	DRAWING NO.	
CHECKED BY	MS	SCALE	AS SPECIFIED	PAGE NO.	
TECH. REVIEWER	HB	SHEET NO.			
DATE	1/22/07				

INDEPENDENCE NATIONAL HISTORICAL PARK