

1314


1313

1312

1311

1310



REVISIONS			
SYM.	DESCRIPTION	DATE	APPROVED
△	CHANGE INVERT	4/27/86	234
△	CALL OUT RCP	4/27/86	234
△	CHANGE INVERT	4/27/86	234
△	CHANGE INVERTS	4/27/86	234
△	RELOCATE SEWER LINE & PUMP STATION	4/27/86	234
△	CHANGE EXIST. LINE SIZE	4/27/86	234

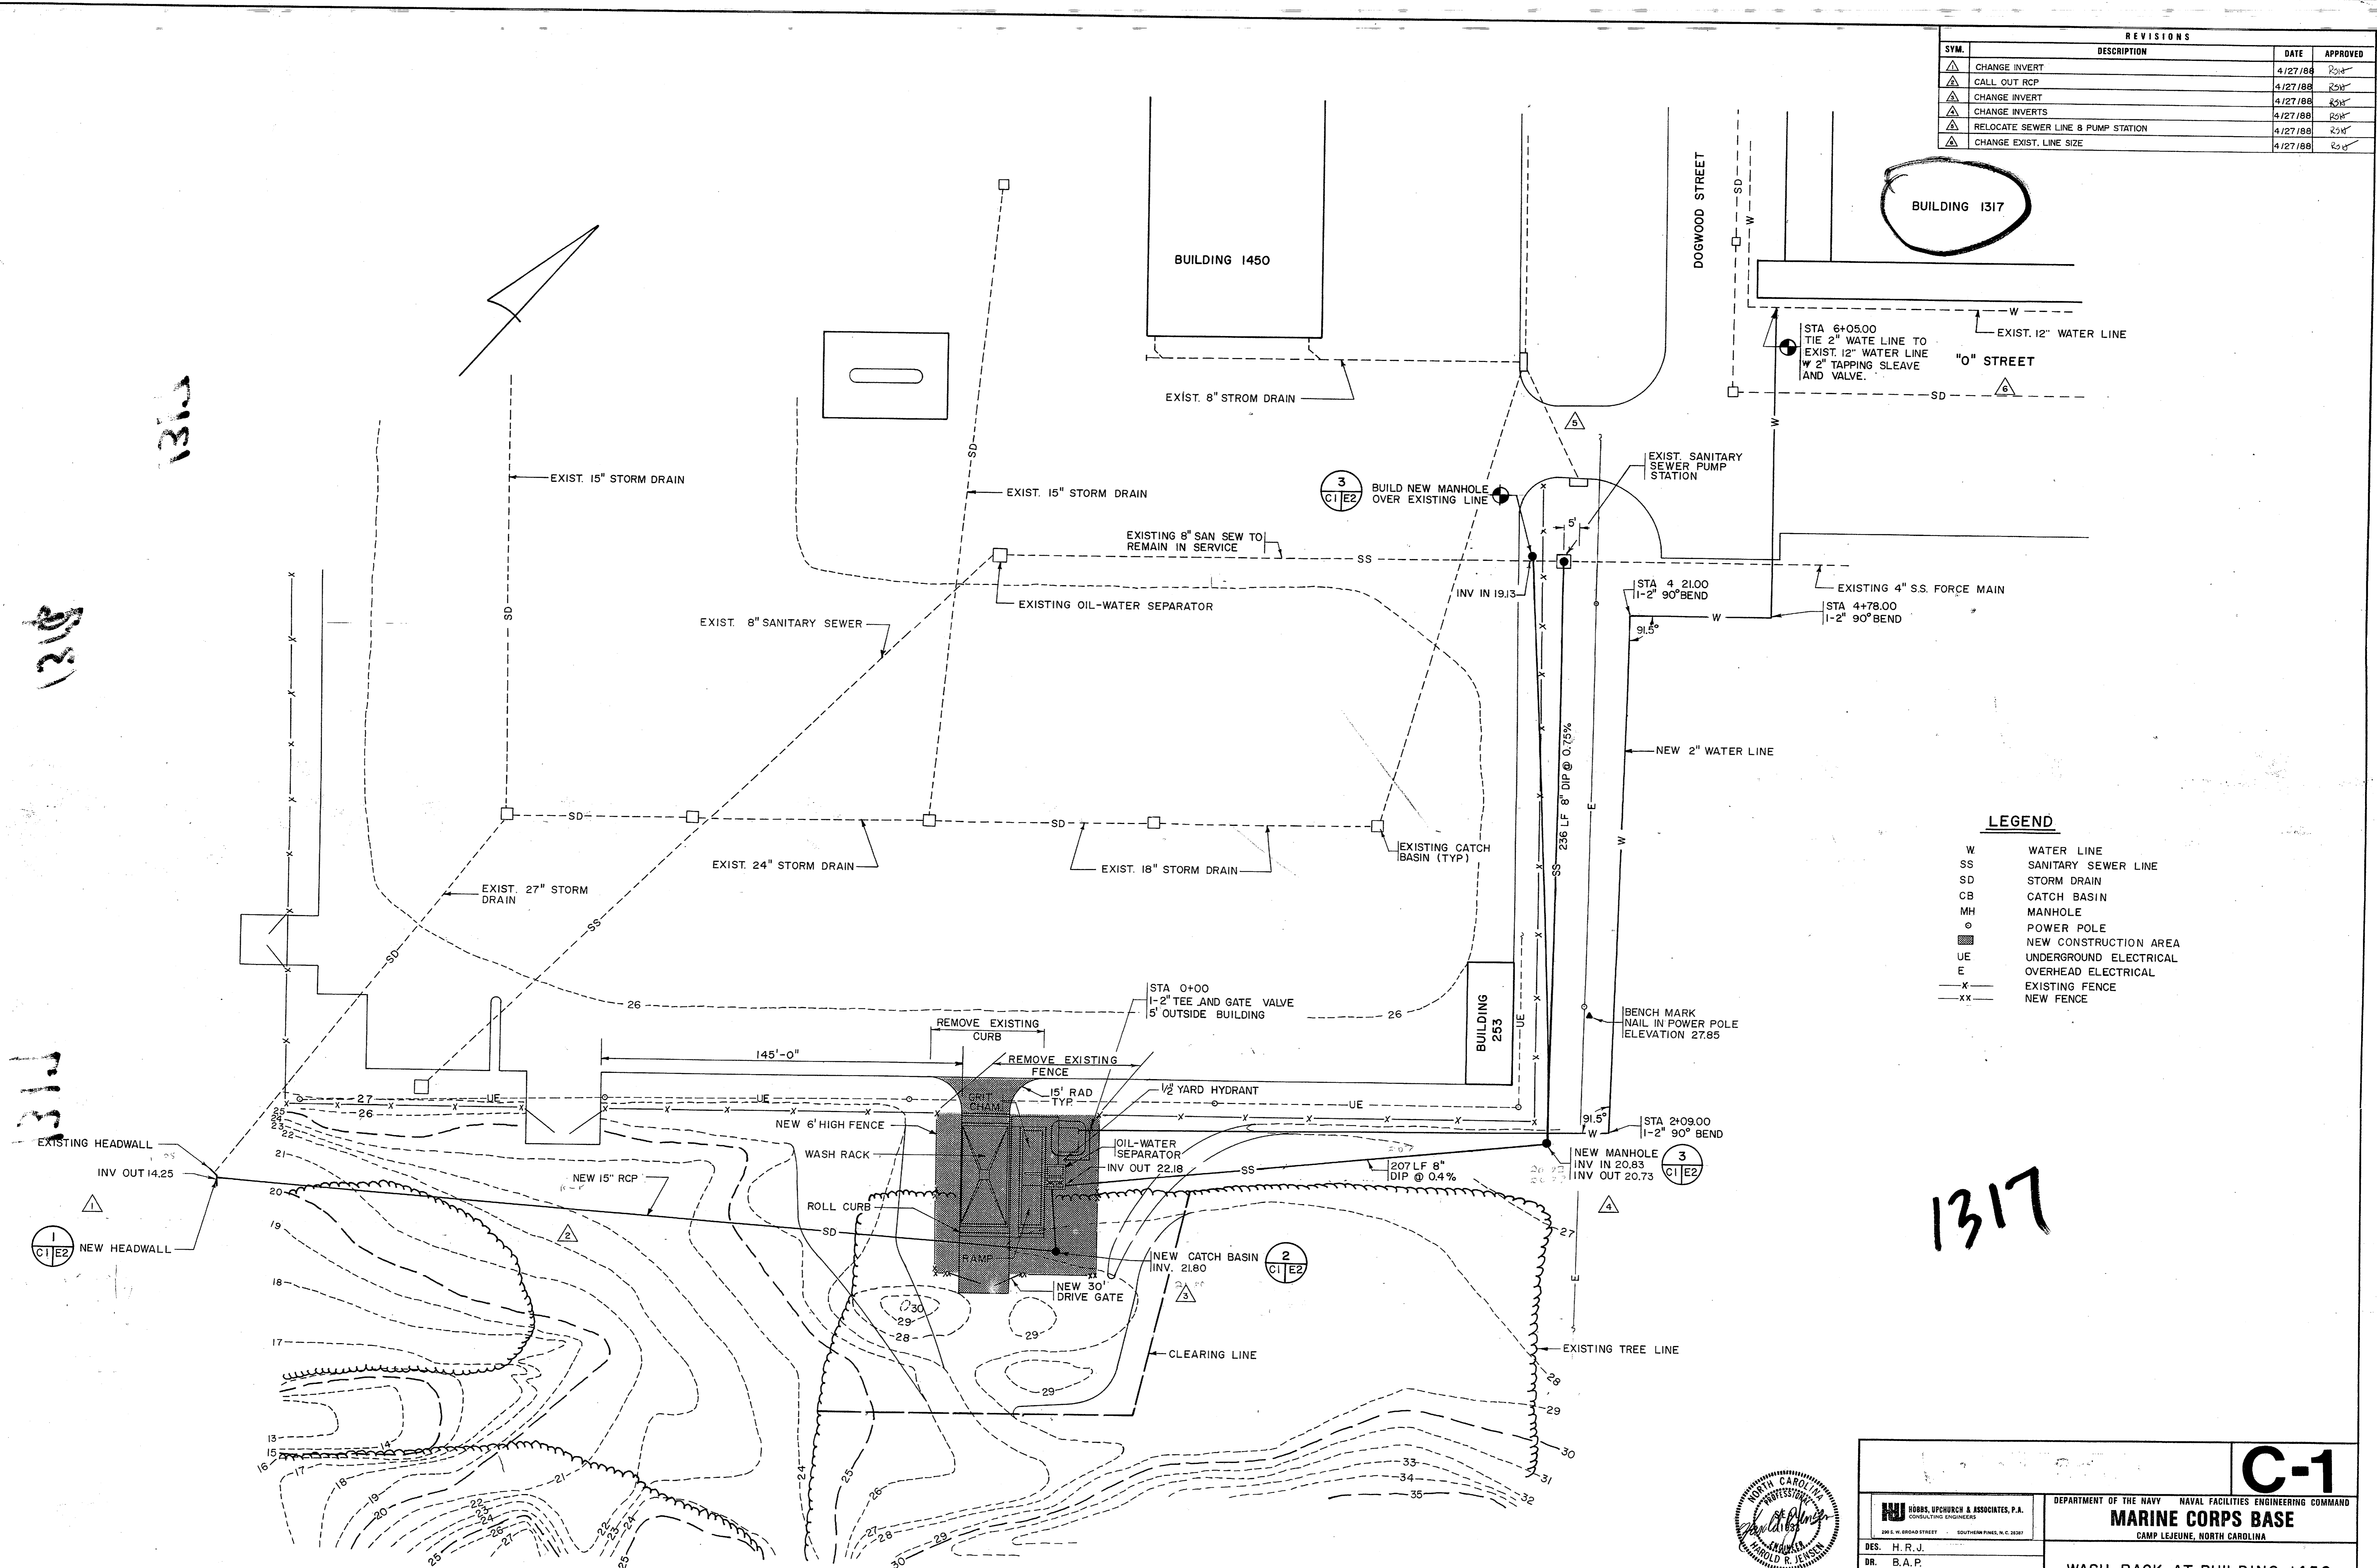

LEGEND

W	WATER LINE
SS	SANITARY SEWER LINE
SD	STORM DRAIN
CB	CATCH BASIN
MH	MANHOLE
o	POWER POLE
■	NEW CONSTRUCTION AREA
UE	UNDERGROUND ELECTRICAL
E	OVERHEAD ELECTRICAL
-x-	EXISTING FENCE
-xx-	NEW FENCE

SITE PLAN
SCALE: 1"=25'

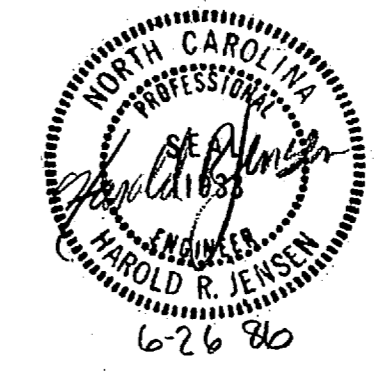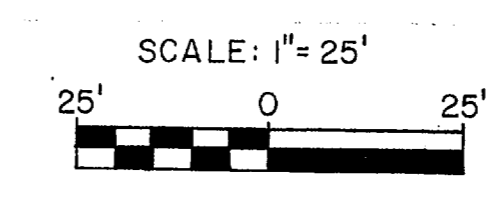

		C-1 DEPARTMENT OF THE NAVY NAVAL FACILITIES ENGINEERING COMMAND MARINE CORPS BASE CAMP LEJEUNE, NORTH CAROLINA	
DES. H. R. J.	DATE	SIZE	CODE IDENT. NO.
CHK. D.T.U.	DATE	SIZE	CODE IDENT. NO.
SUBMITTED BY: D.T.U.	DATE	SIZE	CODE IDENT. NO.
DESIGN DIR. <i>H. R. J.</i>	DATE	SIZE	CODE IDENT. NO.
APPROVED: PWD OR OICC	DATE	SIZE	CODE IDENT. NO.
<i>H. R. J.</i>	7-7-86	F	80091
SATISFACTORY TO:	DATE	SCALE: NOTED	SPEC. 05-86-5420
			SHEET 2 OF 7

1317

1317

1317

1317

1317

1317

1317