


REVISIONS			
SYM.	DESCRIPTION	DATE	APPROVED
1	AS BUILT CONGR.	1-10-80	ROBERT

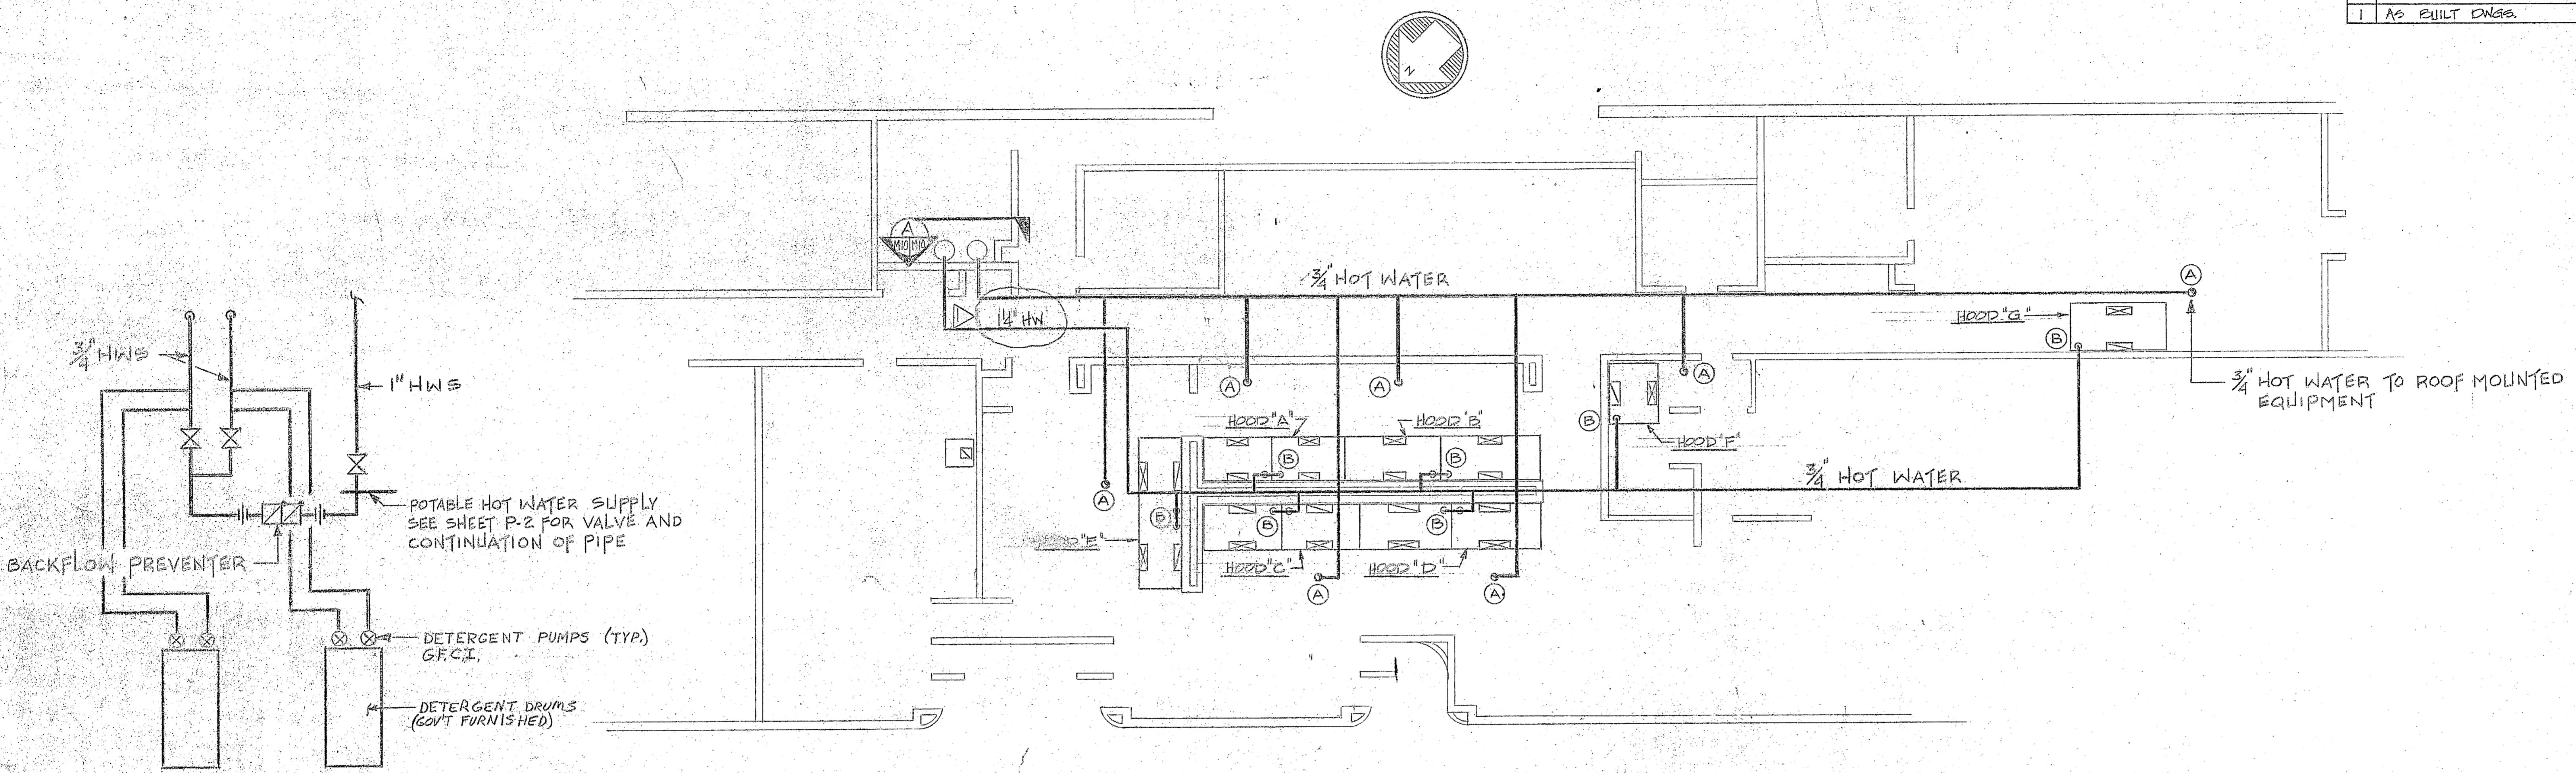

DETAIL A

PARTIAL FLOOR PLAN  
SCALE = 1/8" = 1'-0"

LEGEND:  
 (A) 3/4" HOT WATER PIPES TO ROOF MOUNTED SUPPLY AIR UNIT HEAT RECOVERY DEVICE.  
 (B) 3/4" HOT WATER PIPING DOWN, CONNECTED TO WATER WASH NOZZLES IN VENTILATION HOODS.

NOTE:  
 PROVIDE DRAINS FROM HOODS TO FLOOR DRAINS AS INDICATED IN TYPICAL HOOD SECTION SHOWN ON SHEET M-B, SECTION No. (4) (M-B)

MARK	SUPPLY CFM	MOTOR HP	EXHAUST CFM	MOTOR HP	REMARKS
A	3000	2	3750	5	
B	4000	3	5000	7 1/2	
C	3000	2	3750	5	
D	4000	3	5000	7 1/2	
E	3200	1 1/2	4000	5	
F	1500	1	1875	1 1/2	
G	2400	1 1/2	3000	3	

RECORD DRAWING  
DATE 1-10-80

8106 1270

75128.01  
M-10

LOCKWOOD GREENE ENG., INC.  
SPARTANBURG, S. C. 29301  
ARCHITECTS & ENGINEERS

DEPARTMENT OF THE NAVY  
NAVAL STATION  
ATLANTIC DIVISION  
NORFOLK, VIRGINIA

DES. J. MOORE DR. E. L. DAVENPORT CH. E. BEAM  
PROJ. MGR. J. MOORE CH. ENGR. J. C. COOPER  
DATE 3/2/77

MARINE CORPS BASE, CAMP LEJEUNE, N. C.  
EXCHANGE CAFETERIA & RESTAURANT  
KITCHEN VENTILATION PIPING PLAN  
H. V. A. C.

SIZE CODE IDENT. NO. NAVFAC DRAWING NO.  
80091 4032645

CONSTR. CONTR. NO. N62470-75-B-5229  
SHEET 50 OF 50

SCALE AS NOTED SPEC. 05-75-5328

