



REVISORS			
NO.	DESCRIPTION	DATE	APPROVED

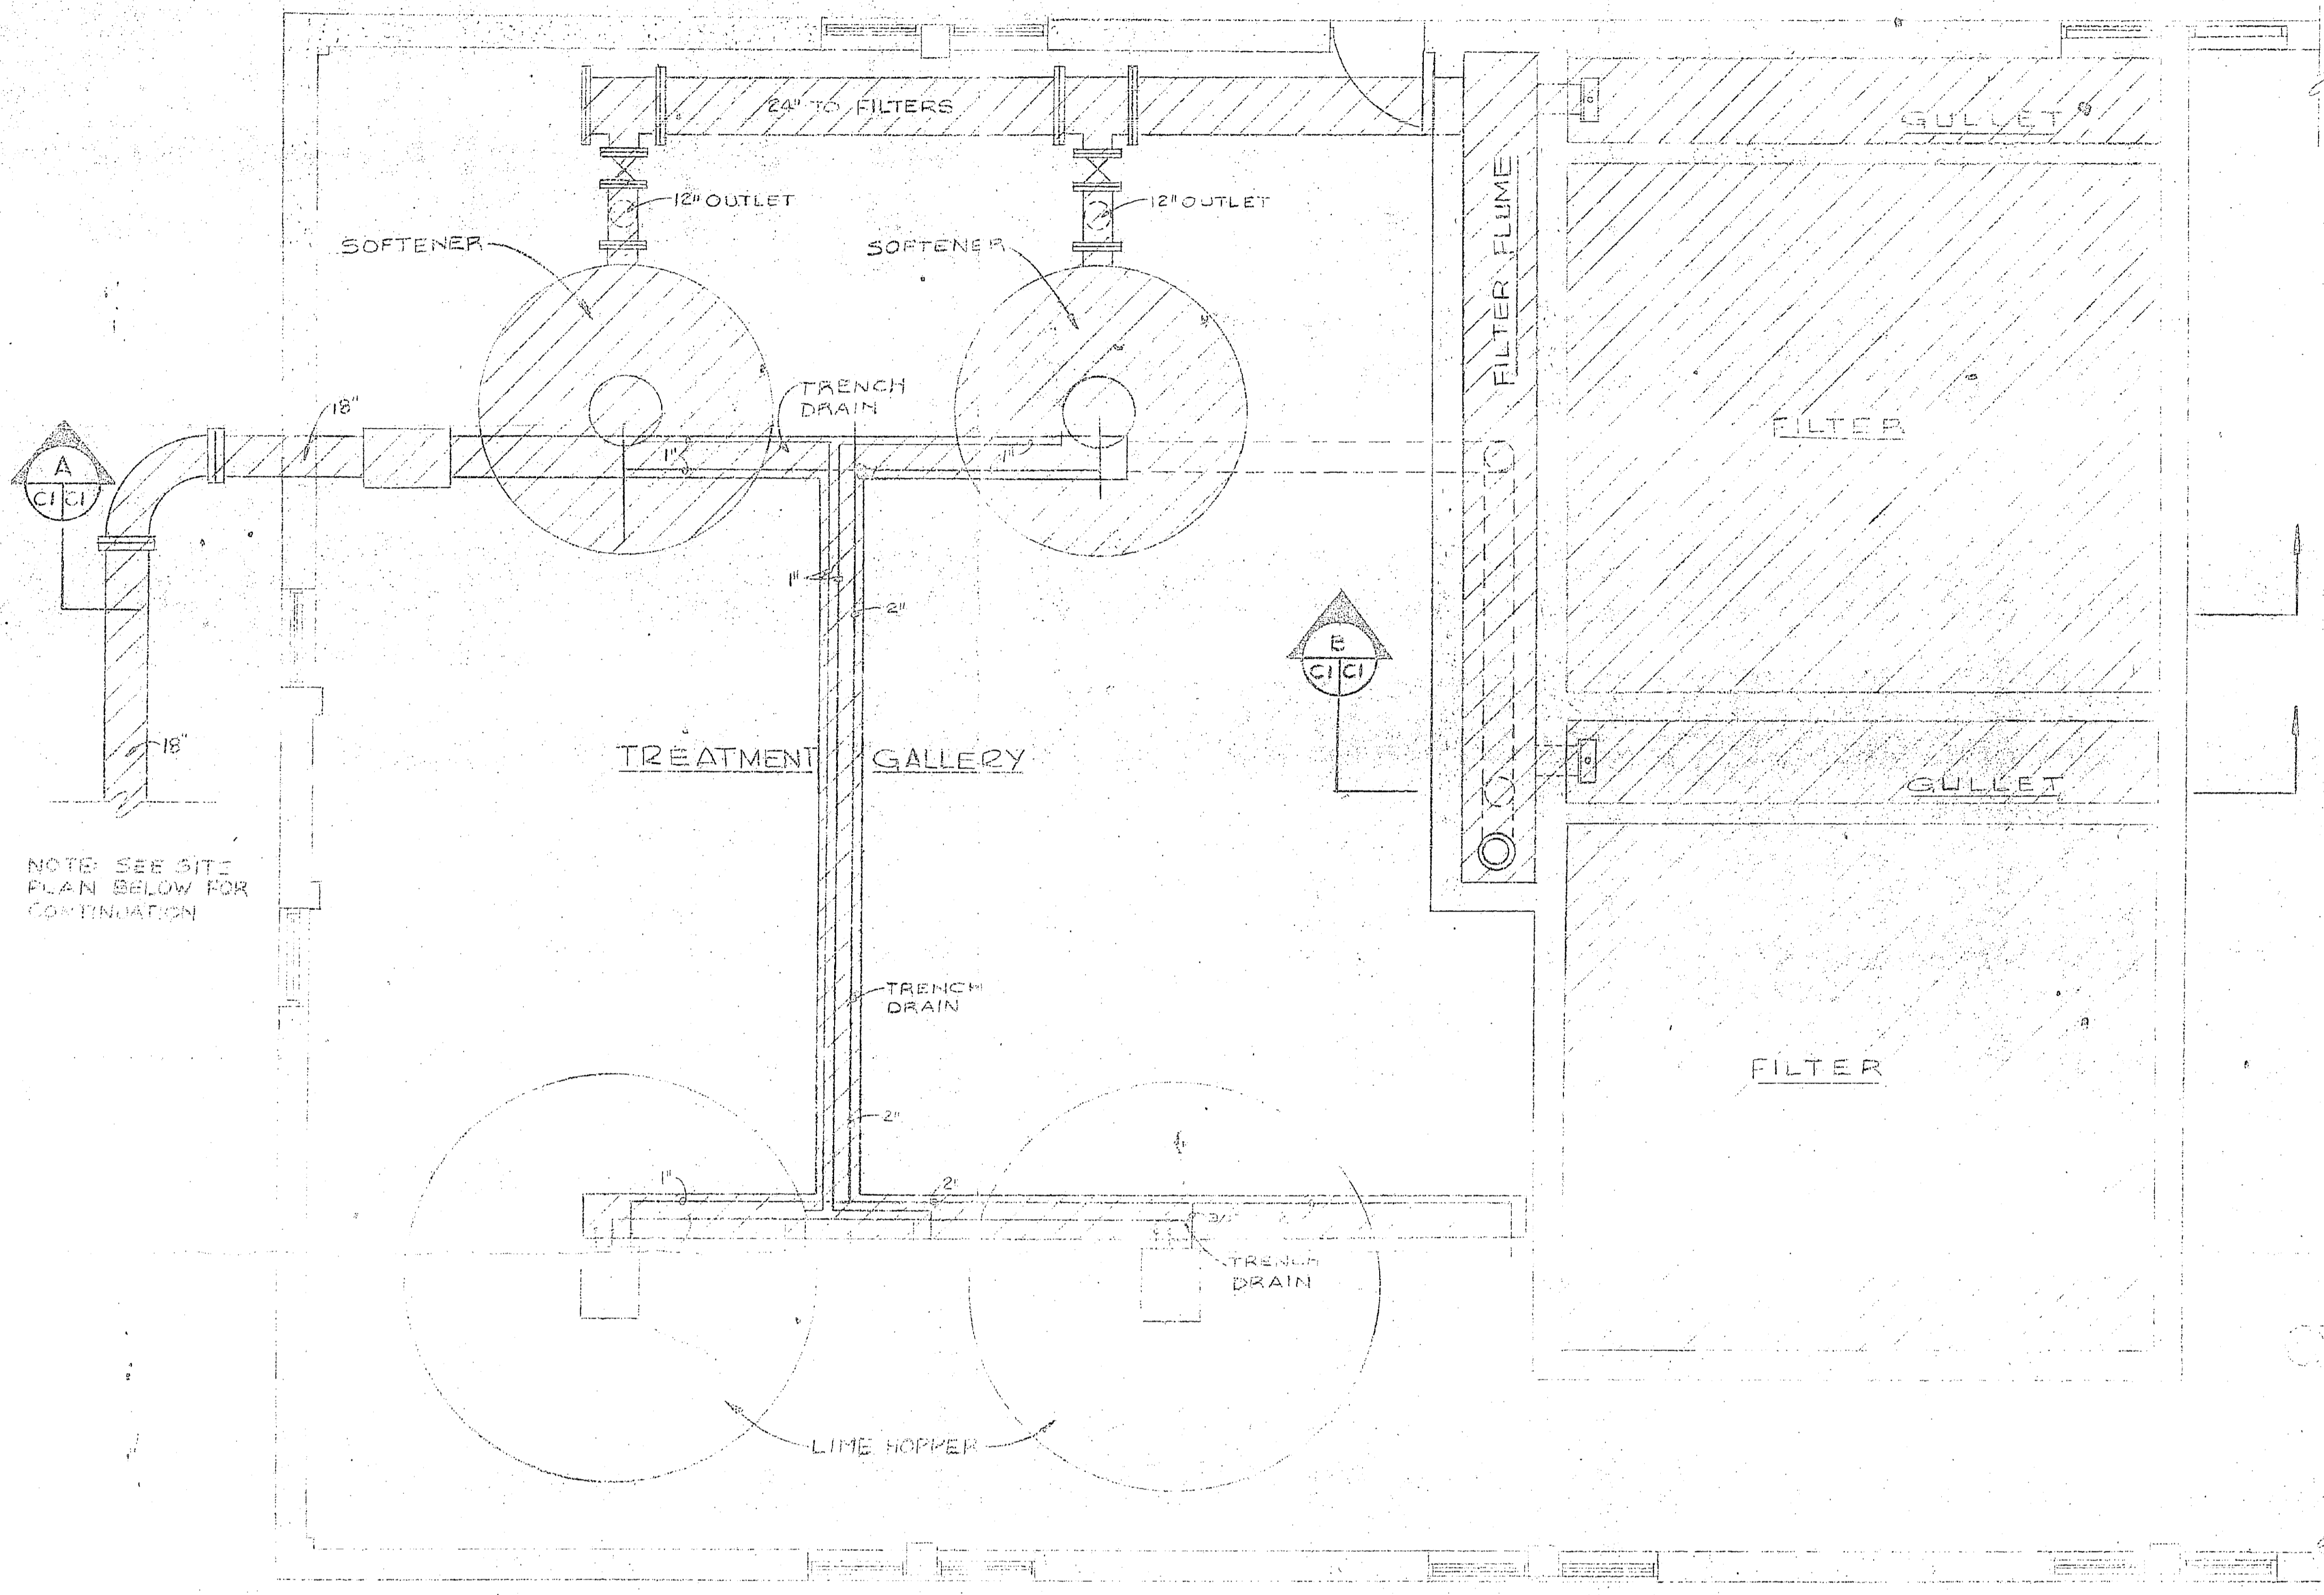


NOTE: SEE SITE PLAN BELOW FOR CONTINUATION

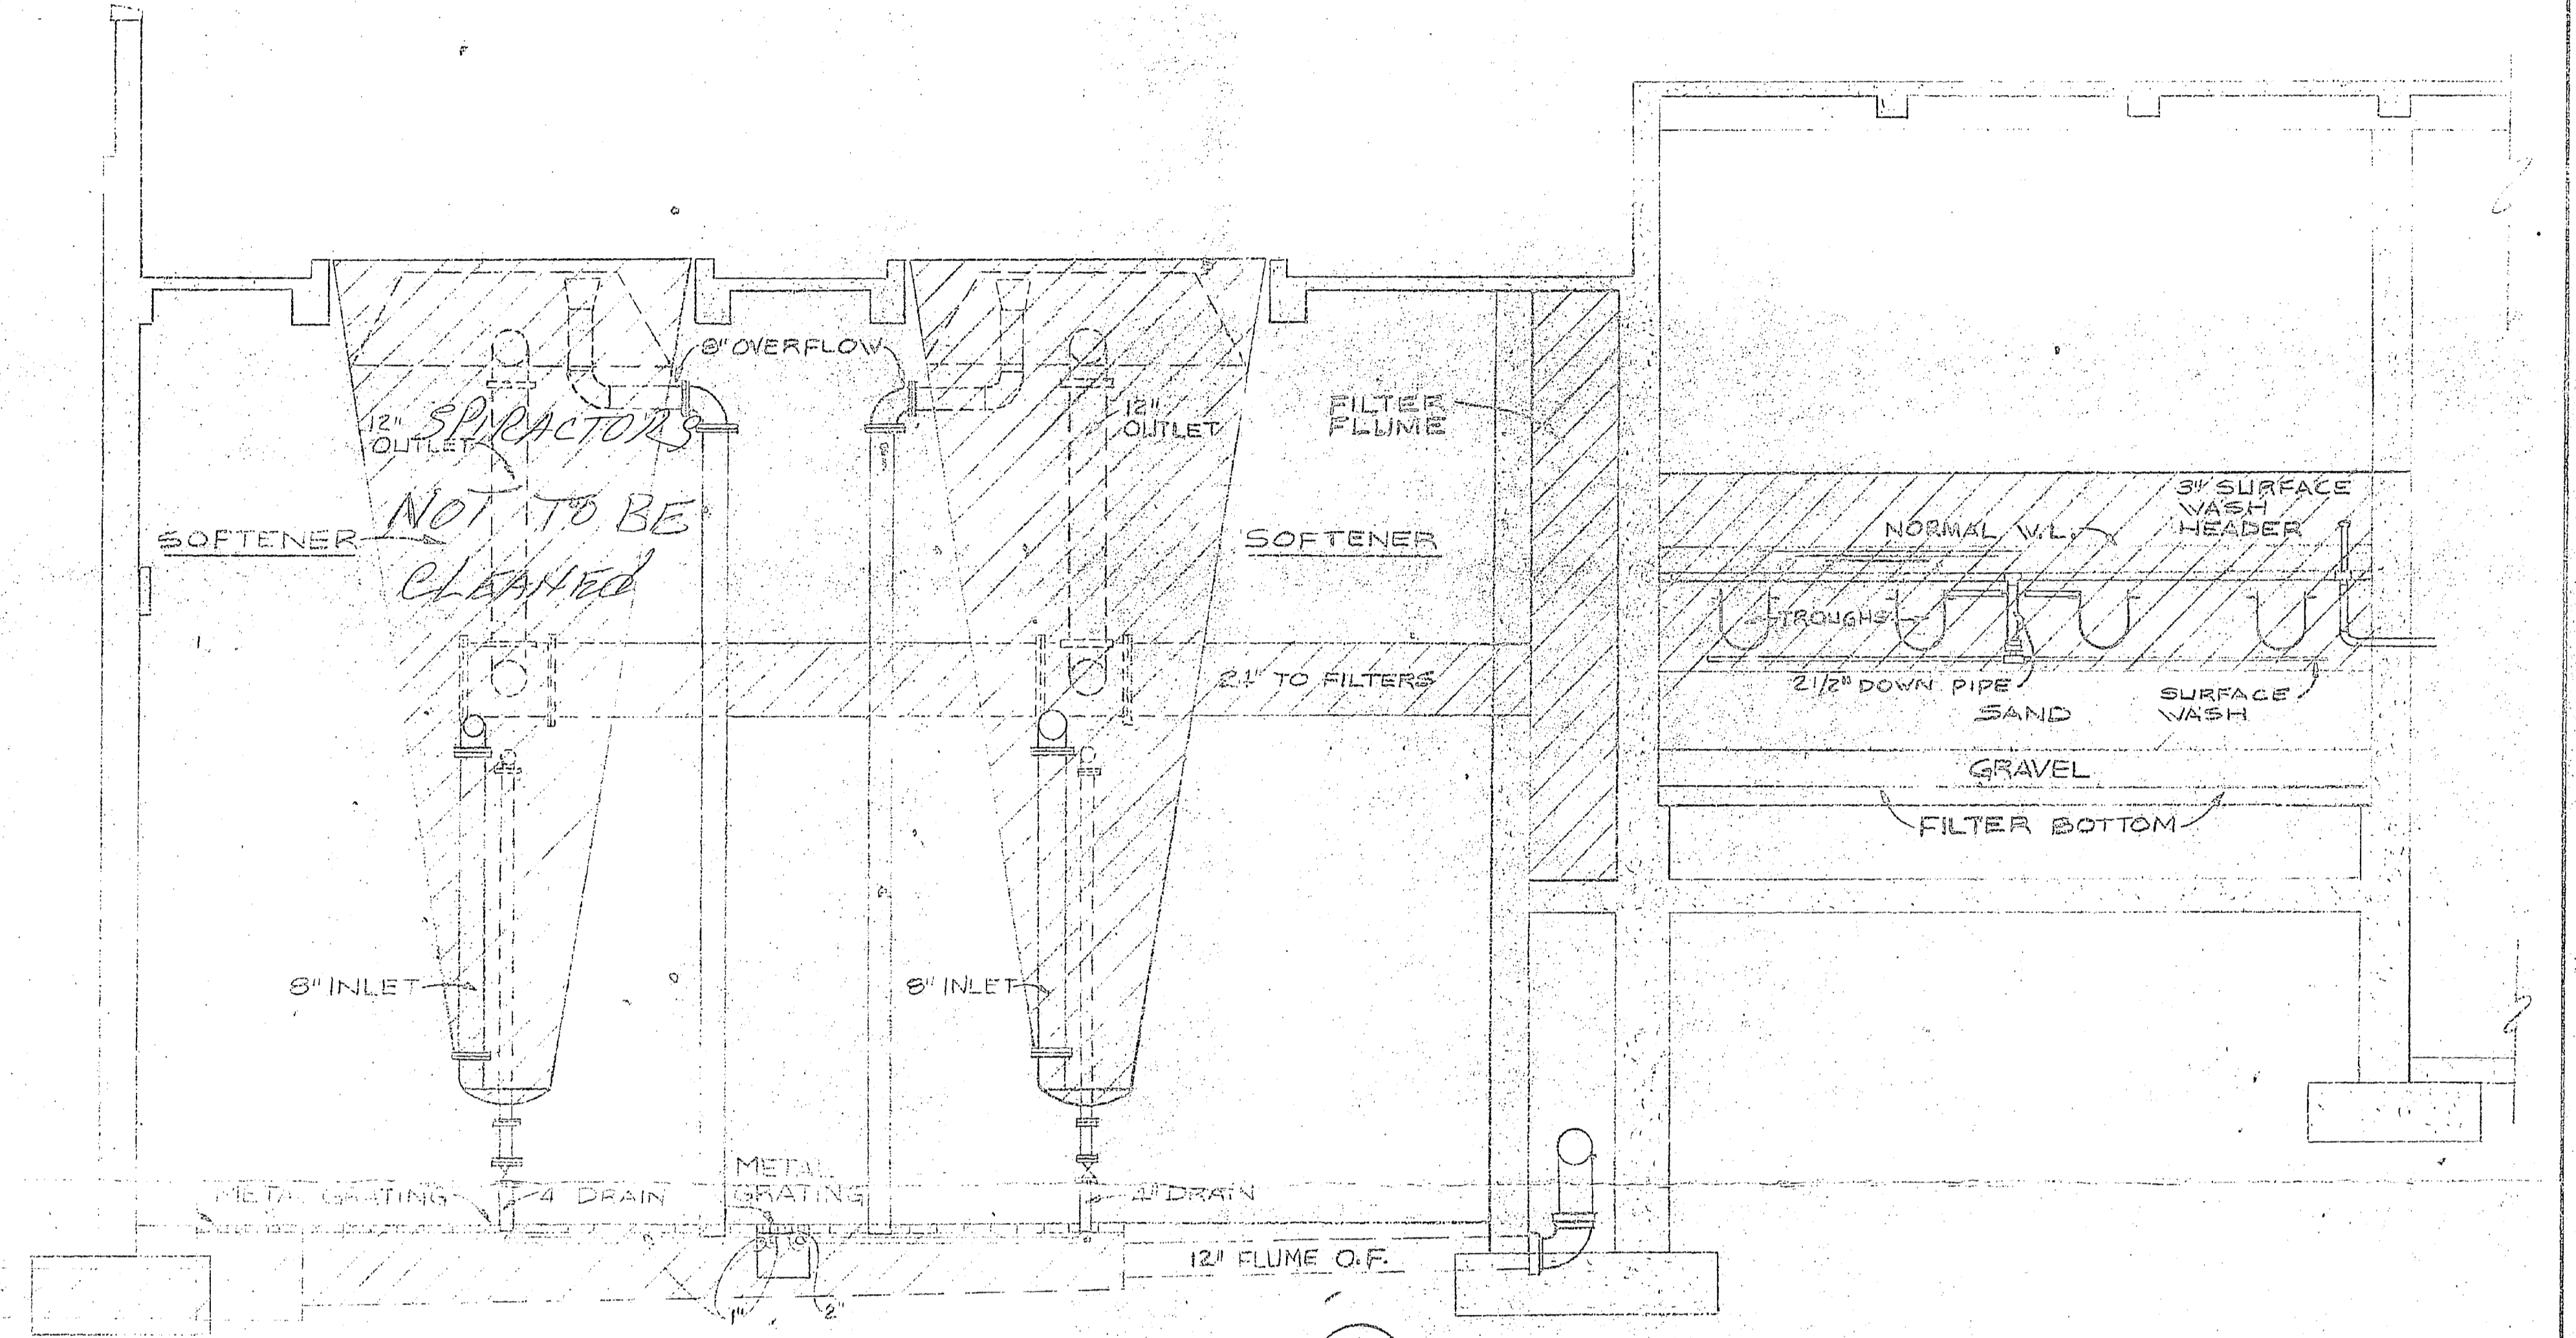


SECTION A-C1-C1
SCALE: 1/4" = 1'-0"


PARTIAL PLAN - 1ST FLOOR
SCALE: 1/8" = 1'-0"

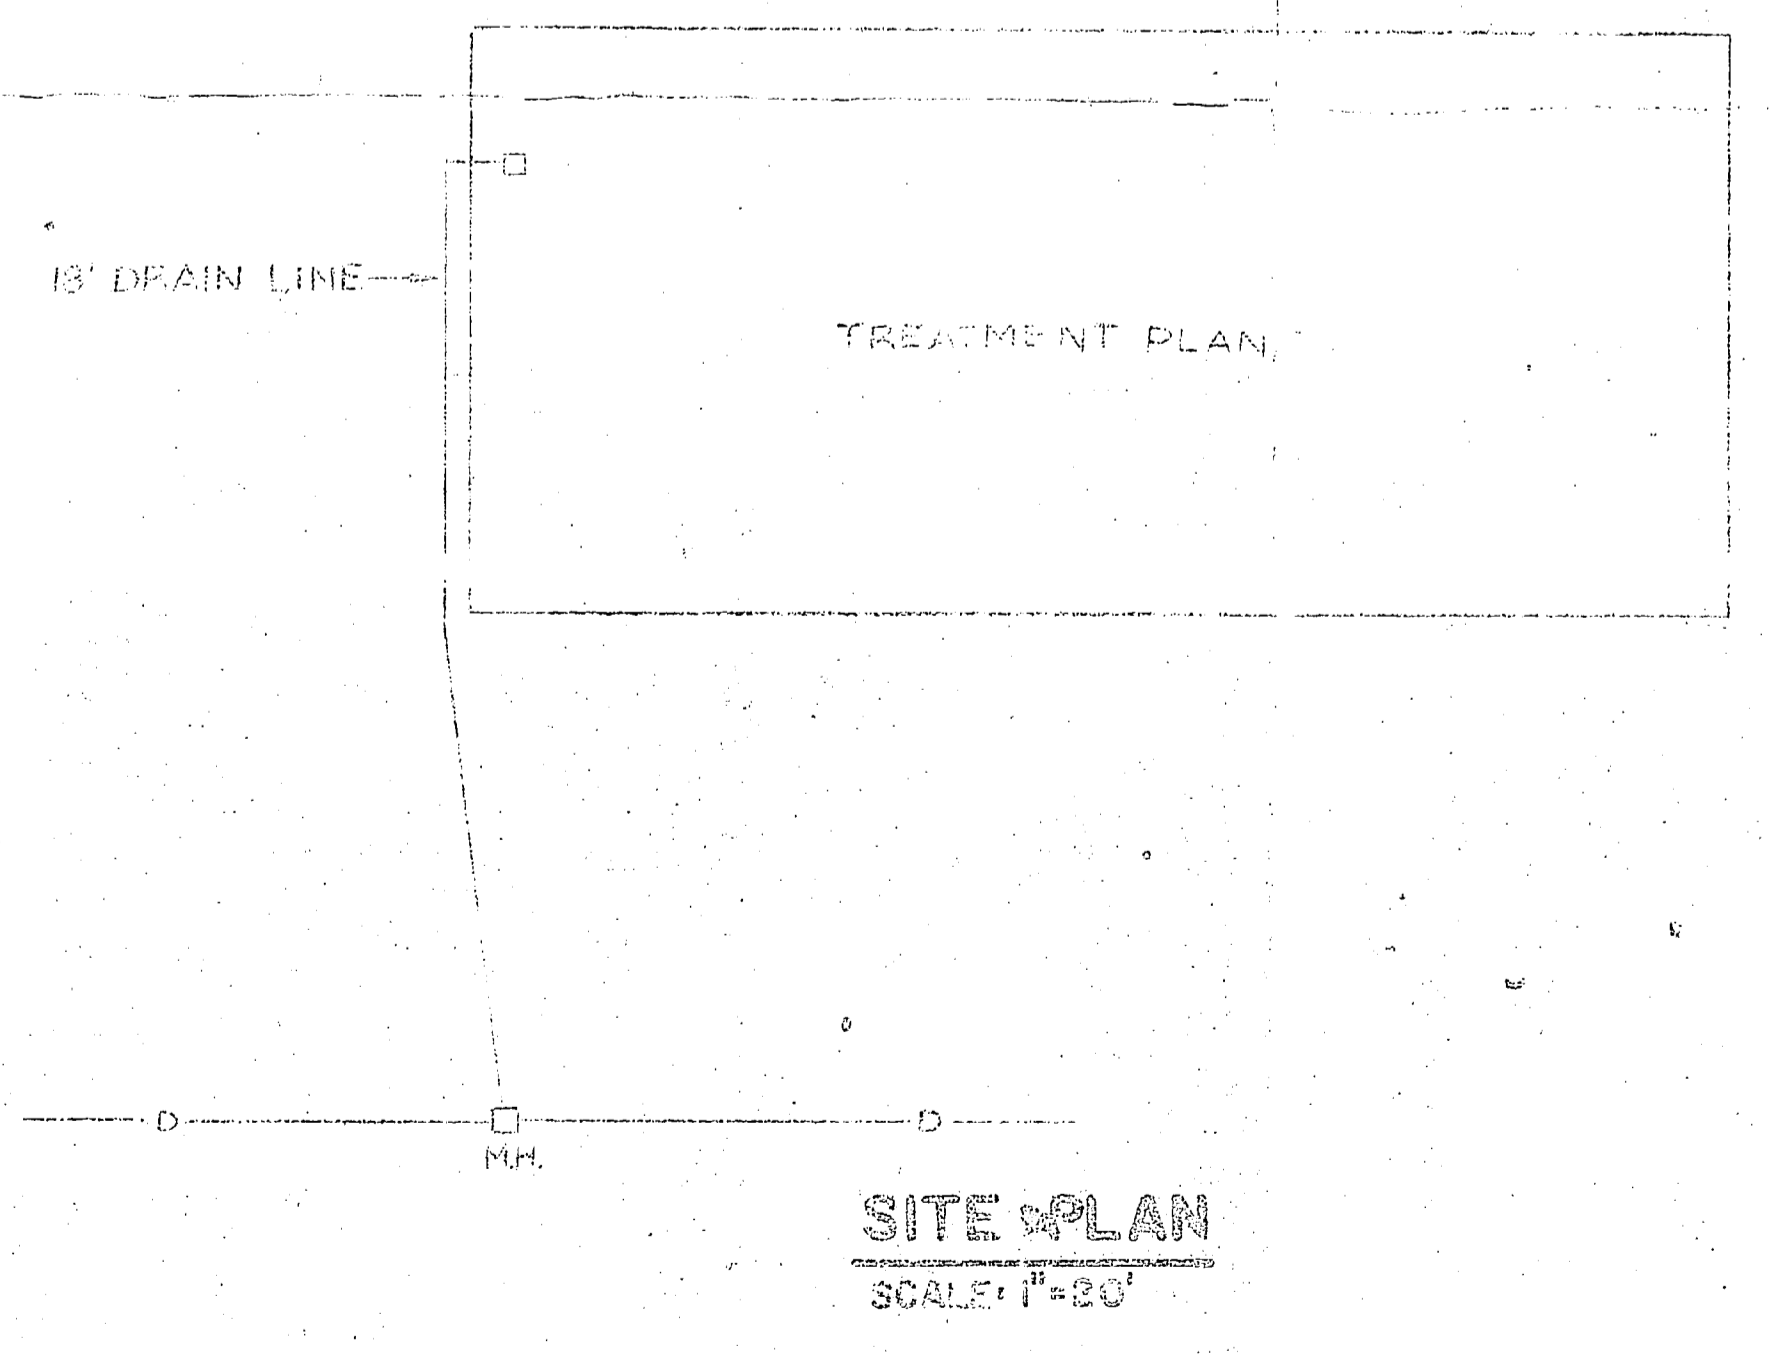

SITE PLAN
SCALE: 1" = 20'

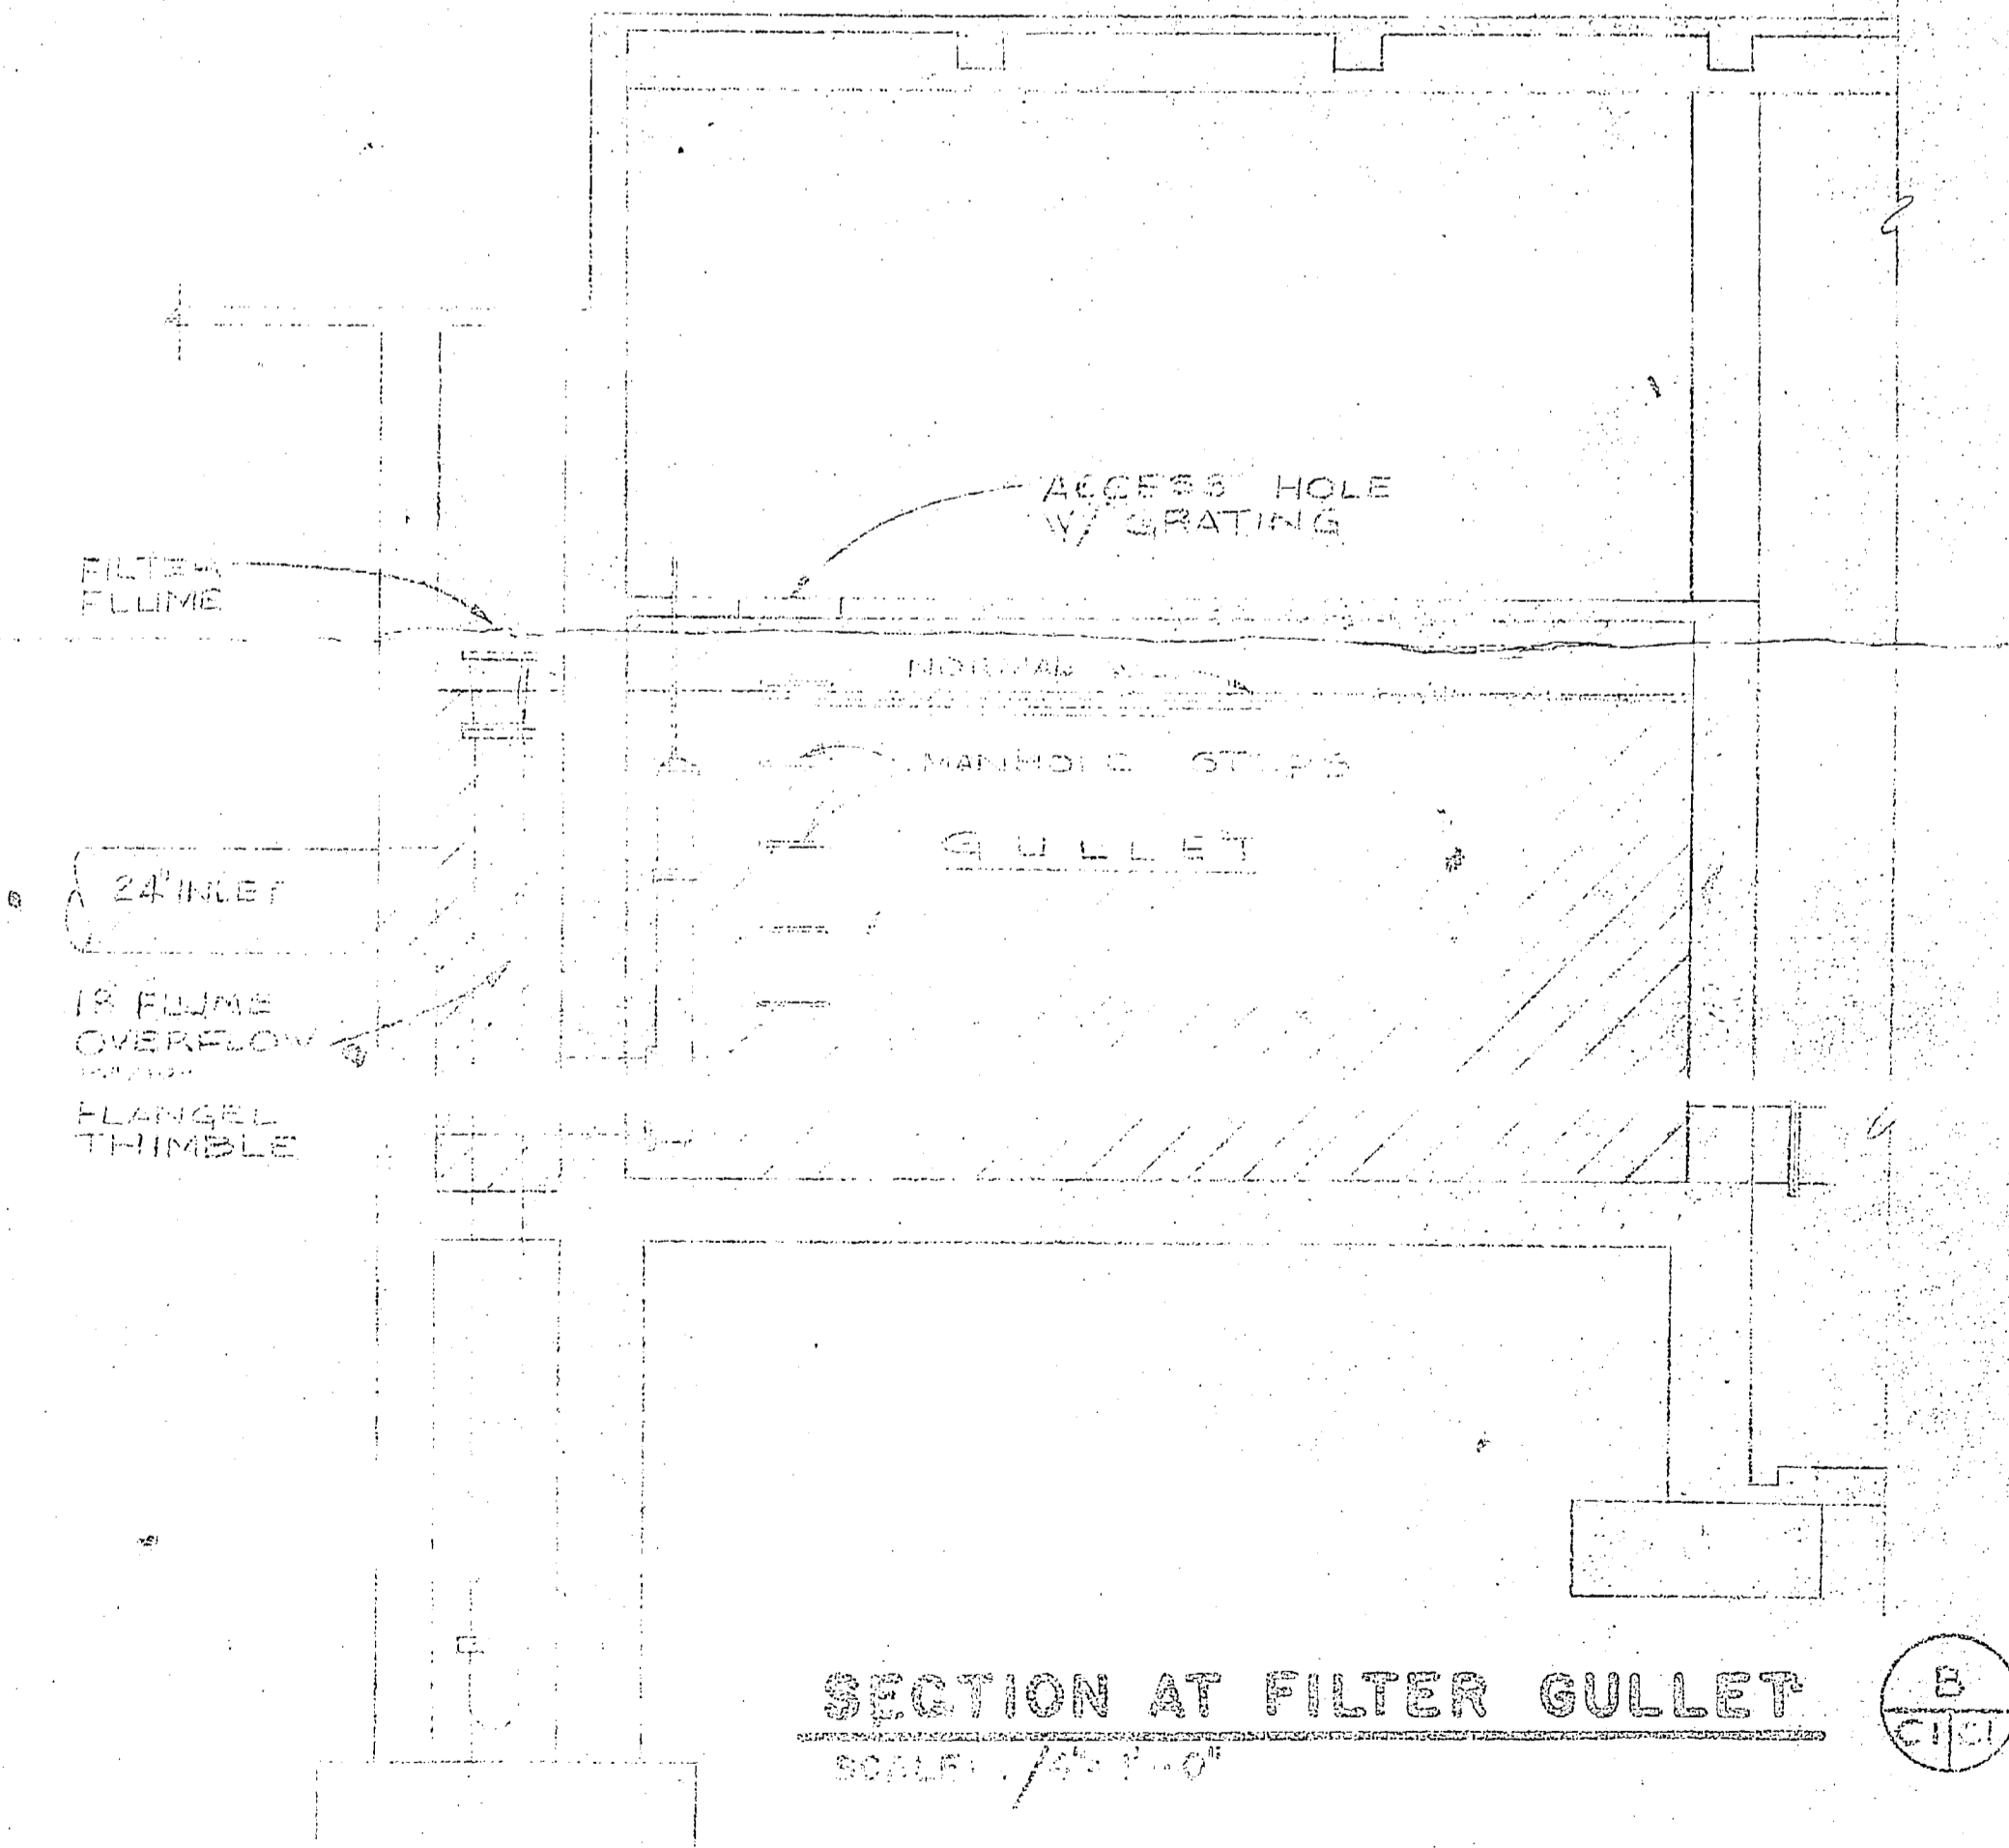

SECTION AT FILTER GULLET
SCALE: 1/4" = 1'-0"

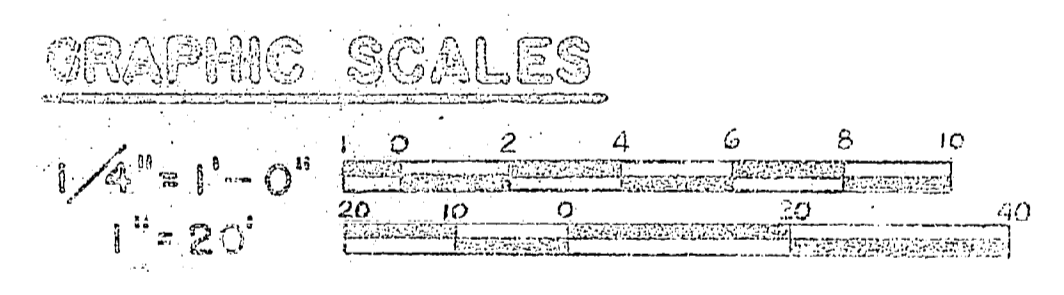

DES. C. BAKER DR. C. BAKER CHK. R. AGYON SUBMITTED BY: DESIGN NO. APPROVED: PCH OR GIC DATE		DATE		SIZE		COST UNIT NO.		SHEET NO.		DEPARTMENT OF THE NAVY	
										MARINE CORPS BASE	
SATISFACTORY TO:		DATE		SCALE		DRAWN		CHECKED		C-1	
CHEMICALLY CLEAN PIPING/EQUIPMENT BLDG. GYO AND REPLACE WATER PIPING IN POOLS		PLANS		00001		1		1		1	

