

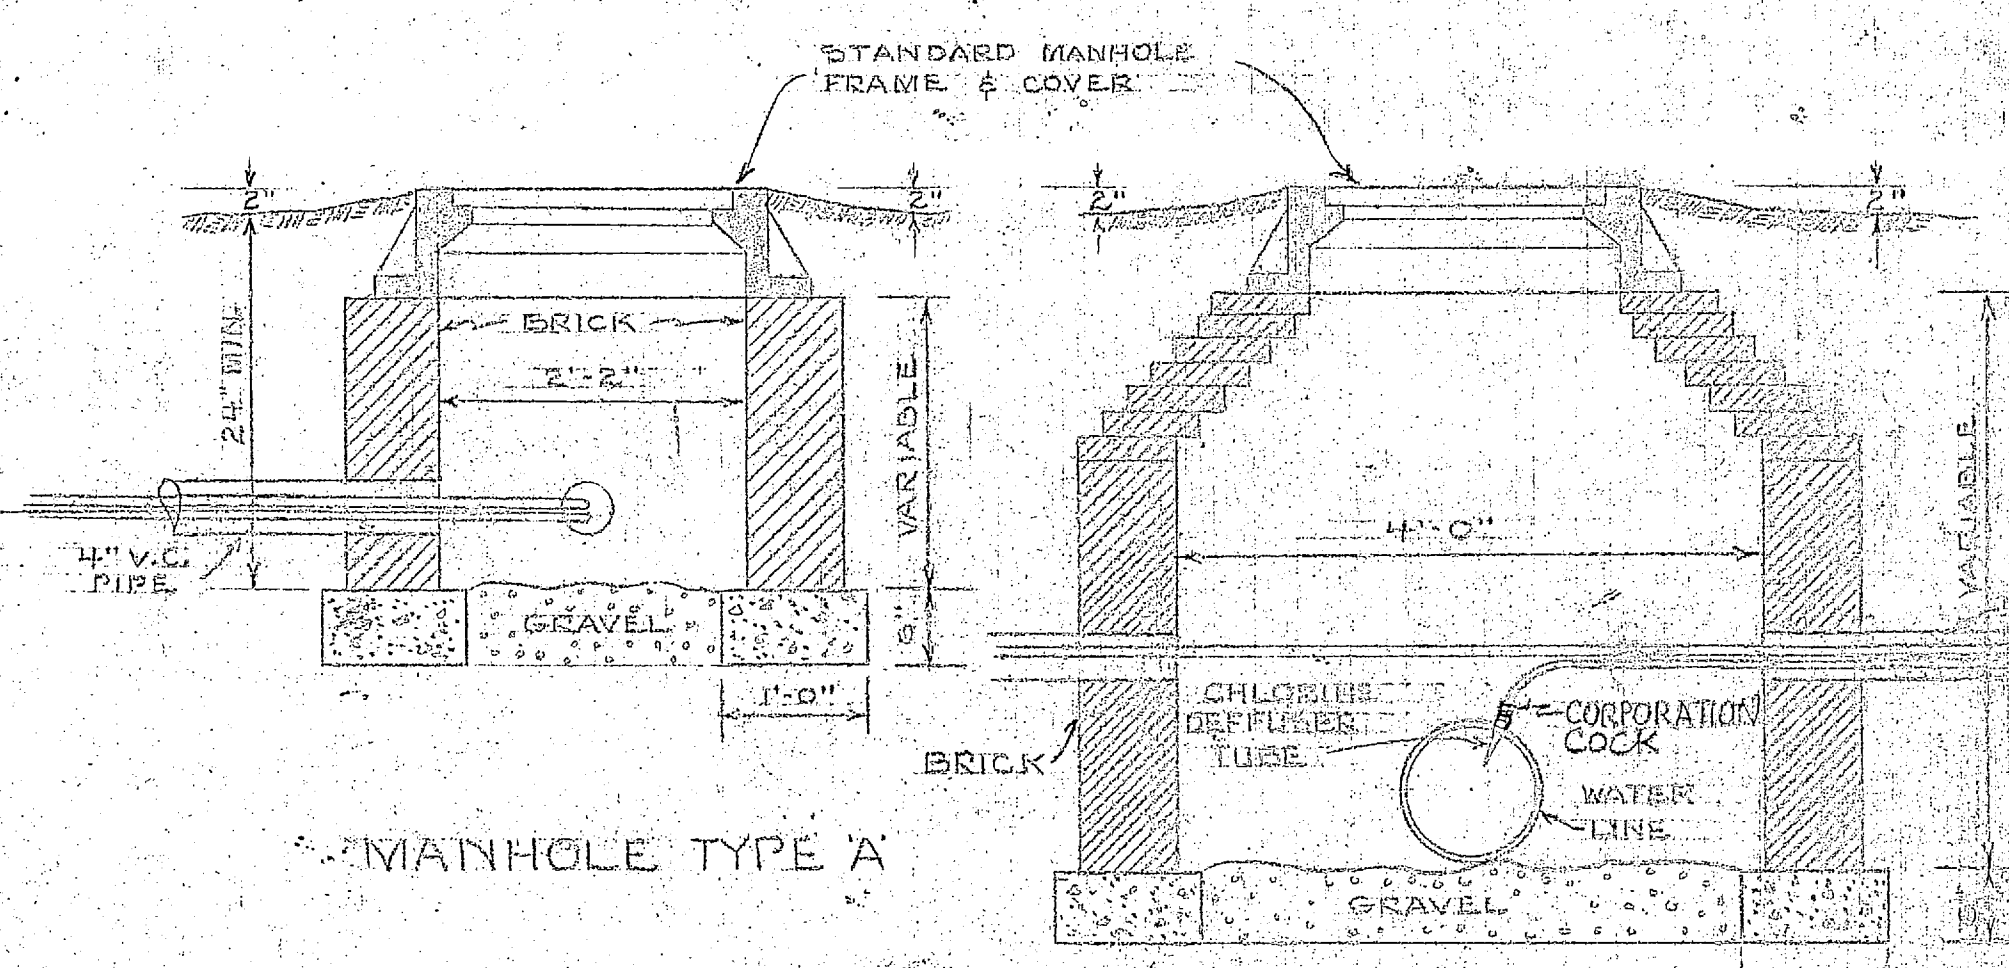
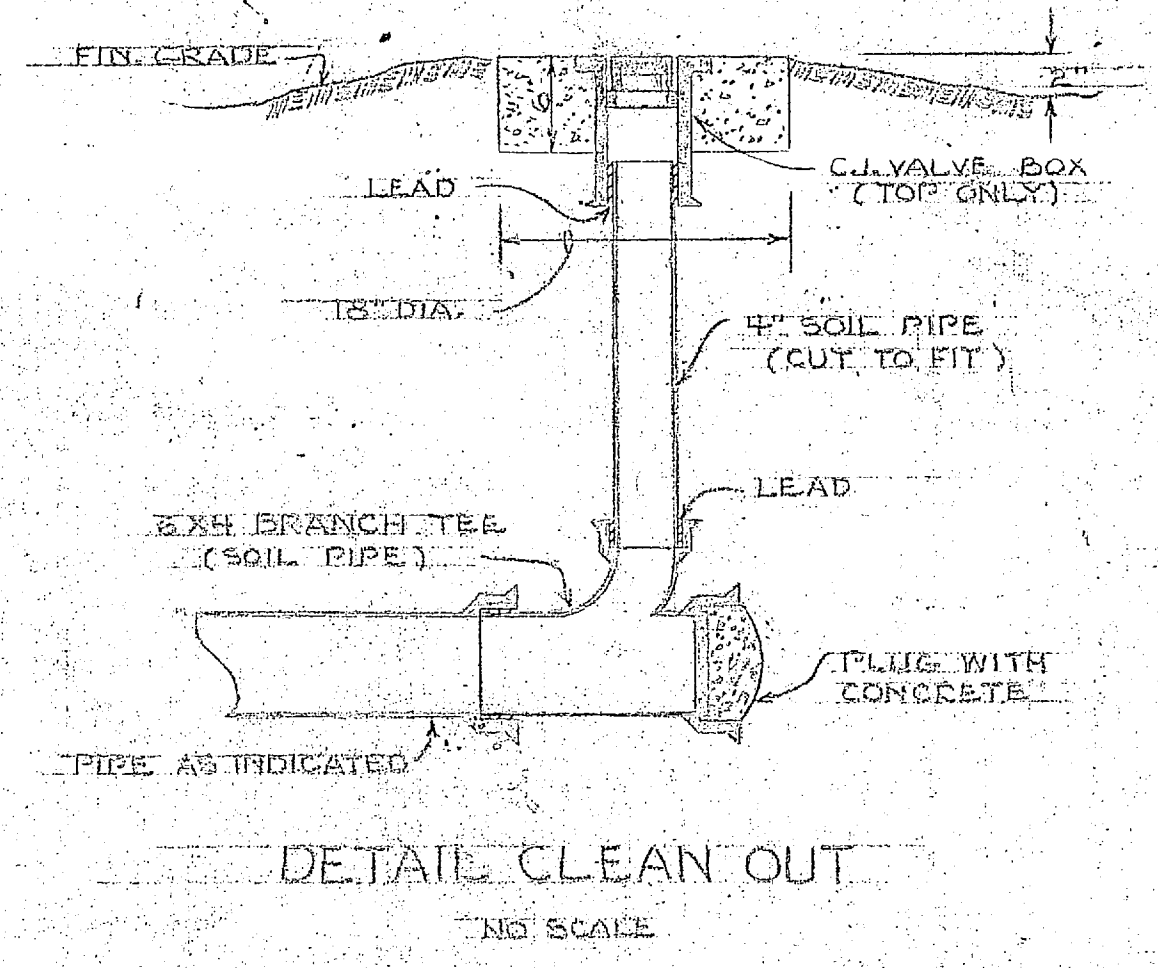
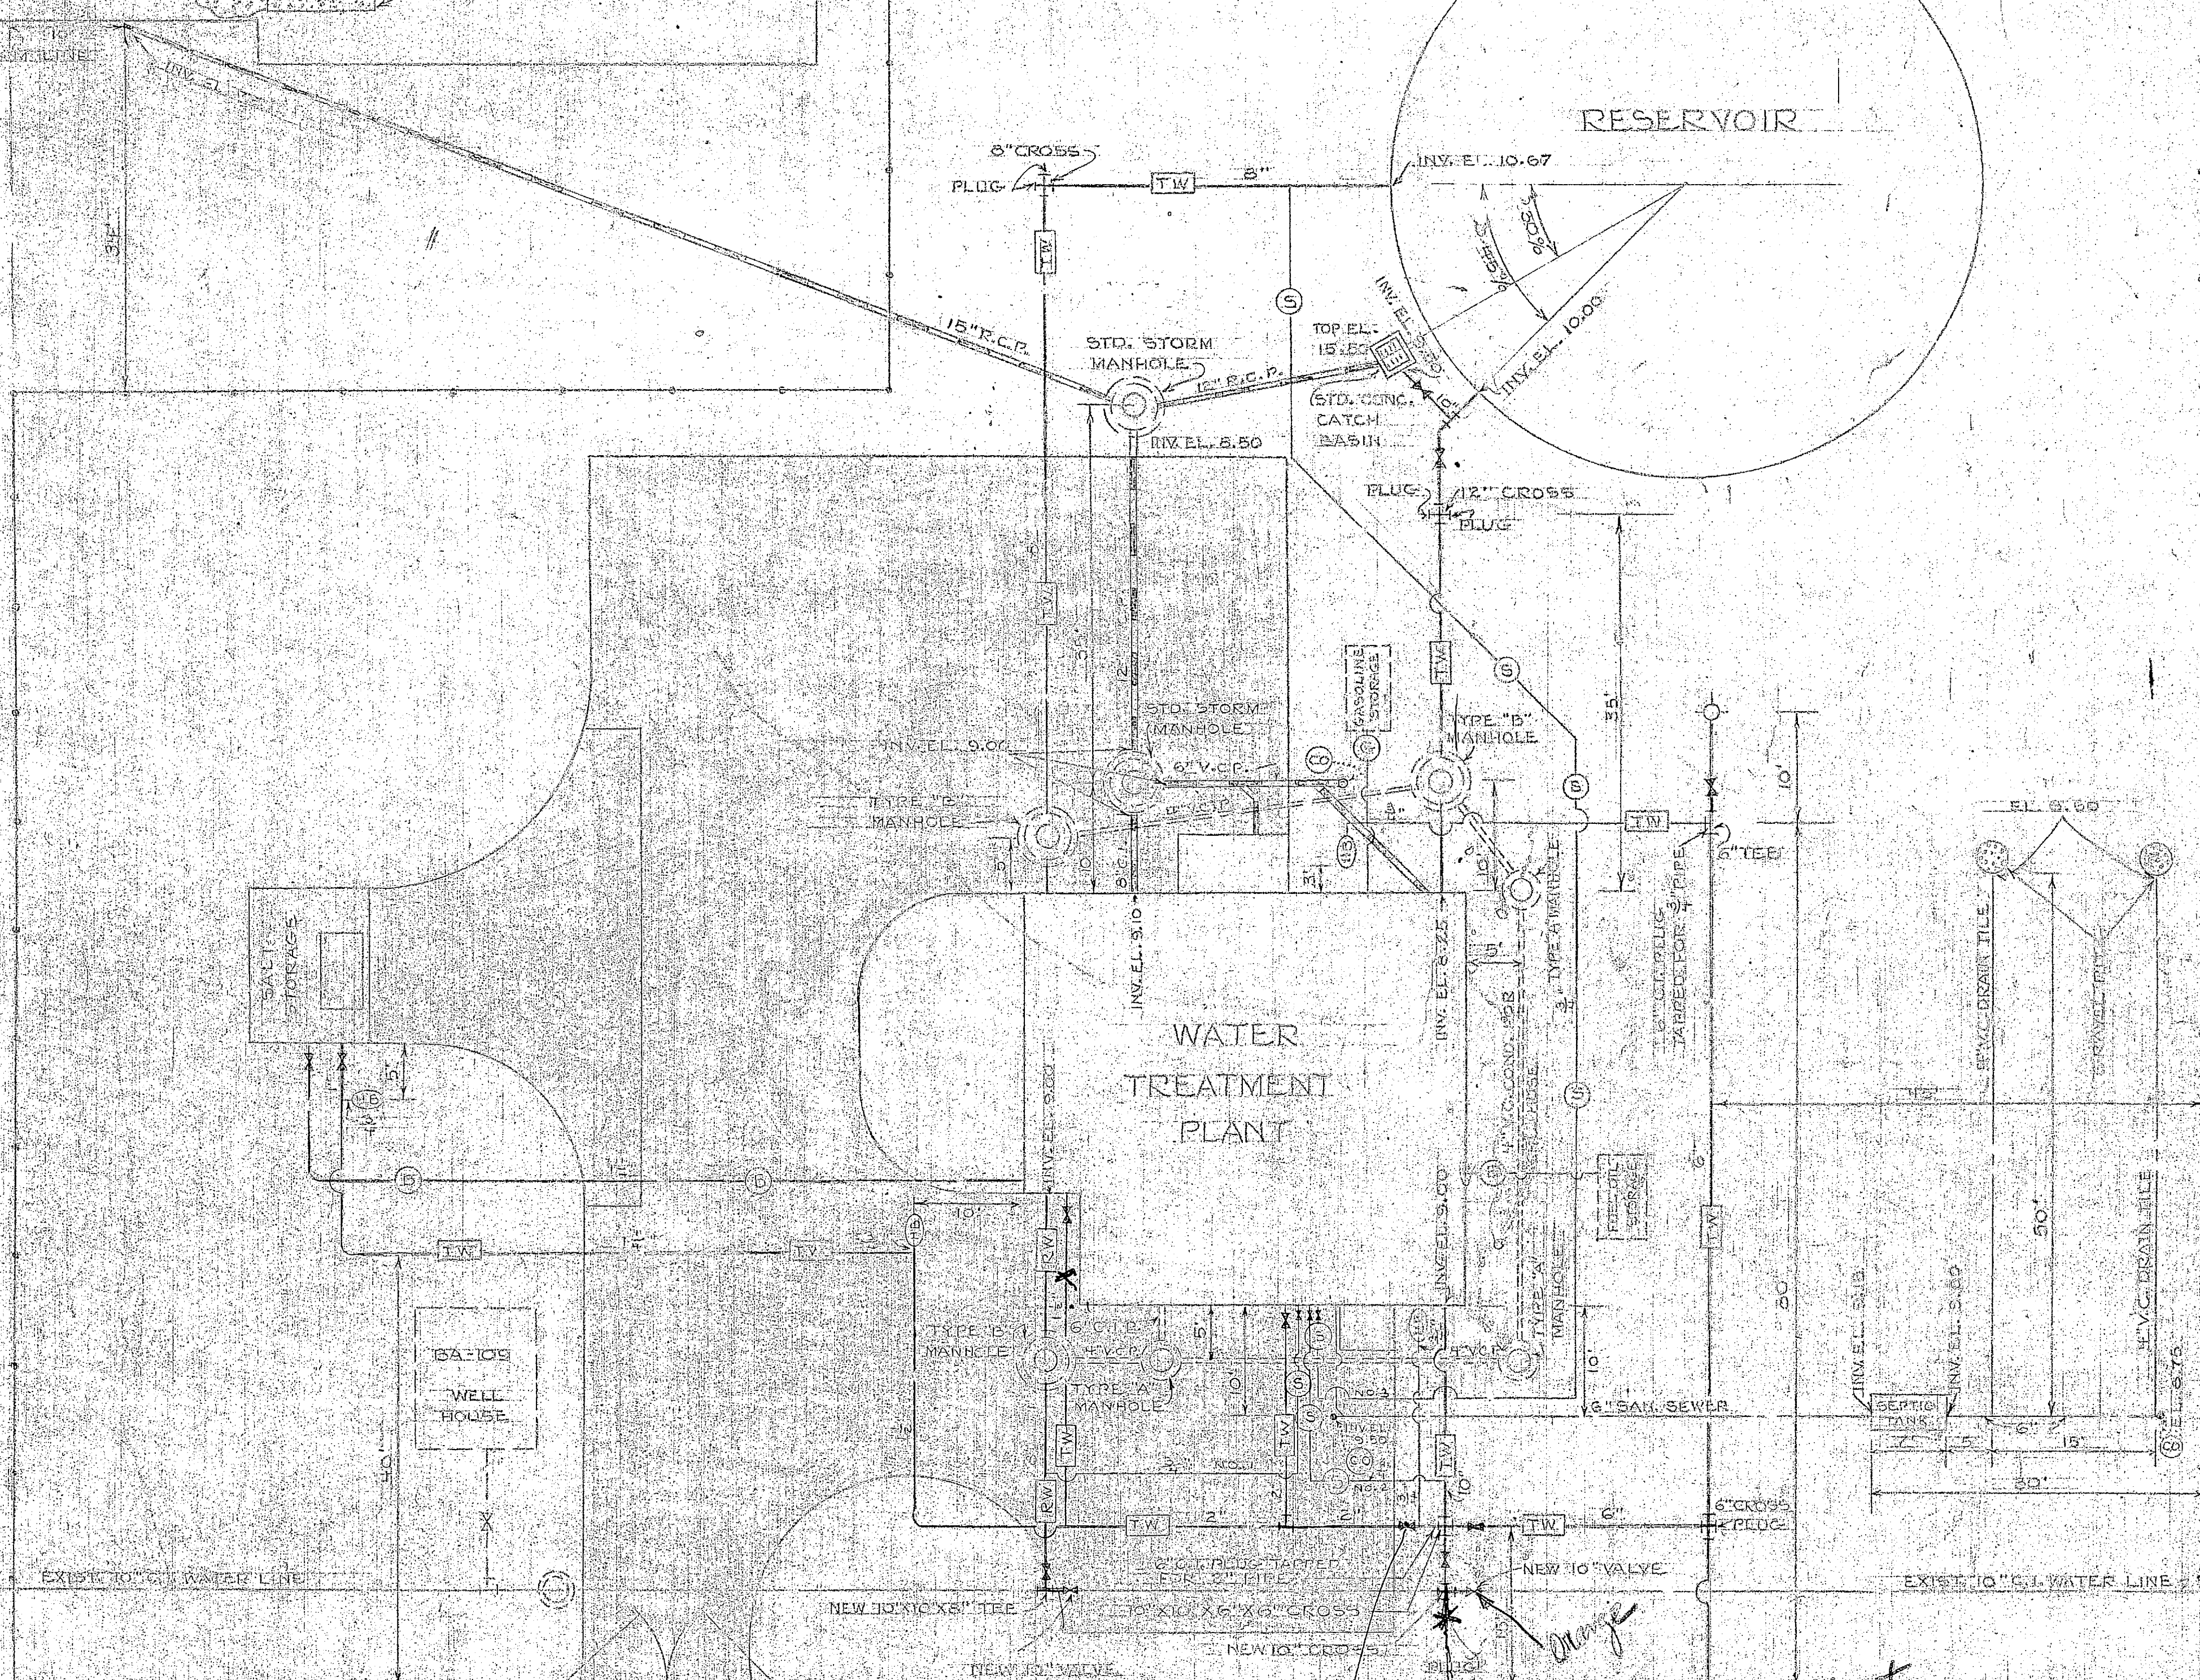
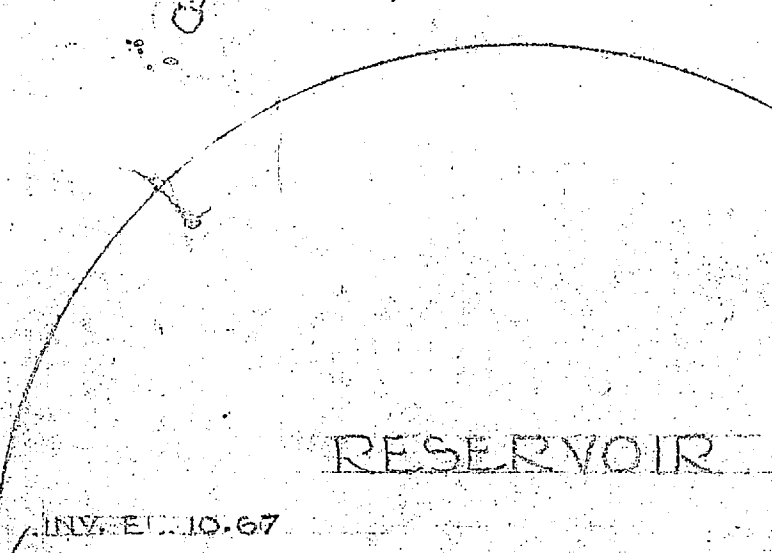




HYDRANT DETAIL
NO SCALE

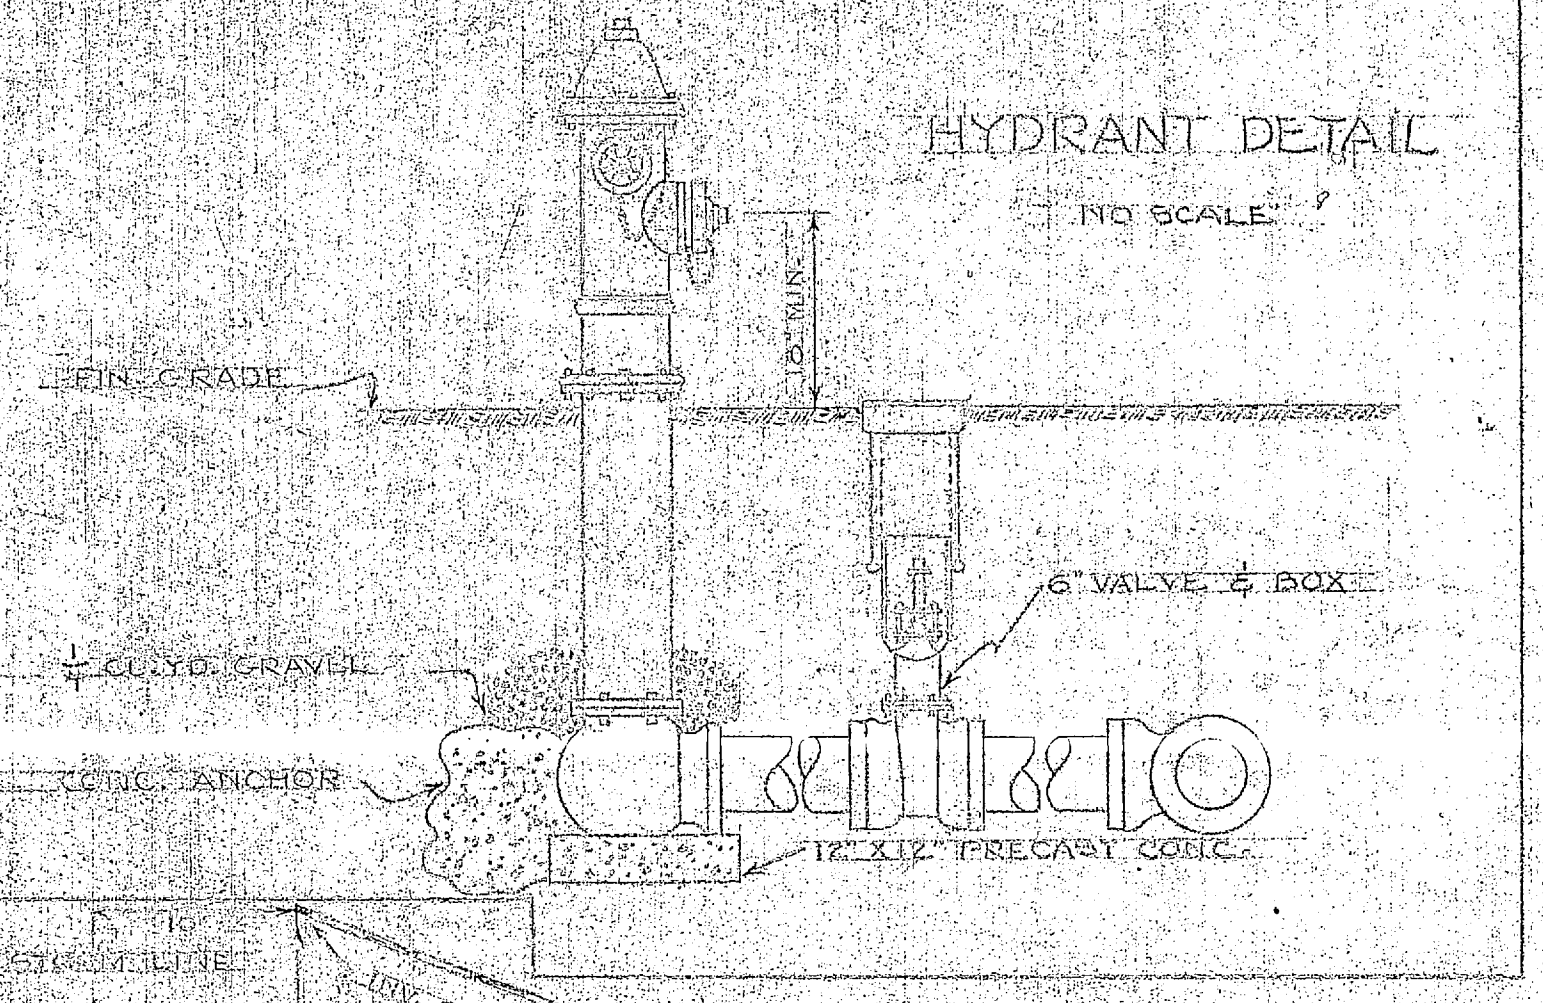


TYPICAL CHLORINATION MANHOLES
SCALE 1/8" = 1'-0"

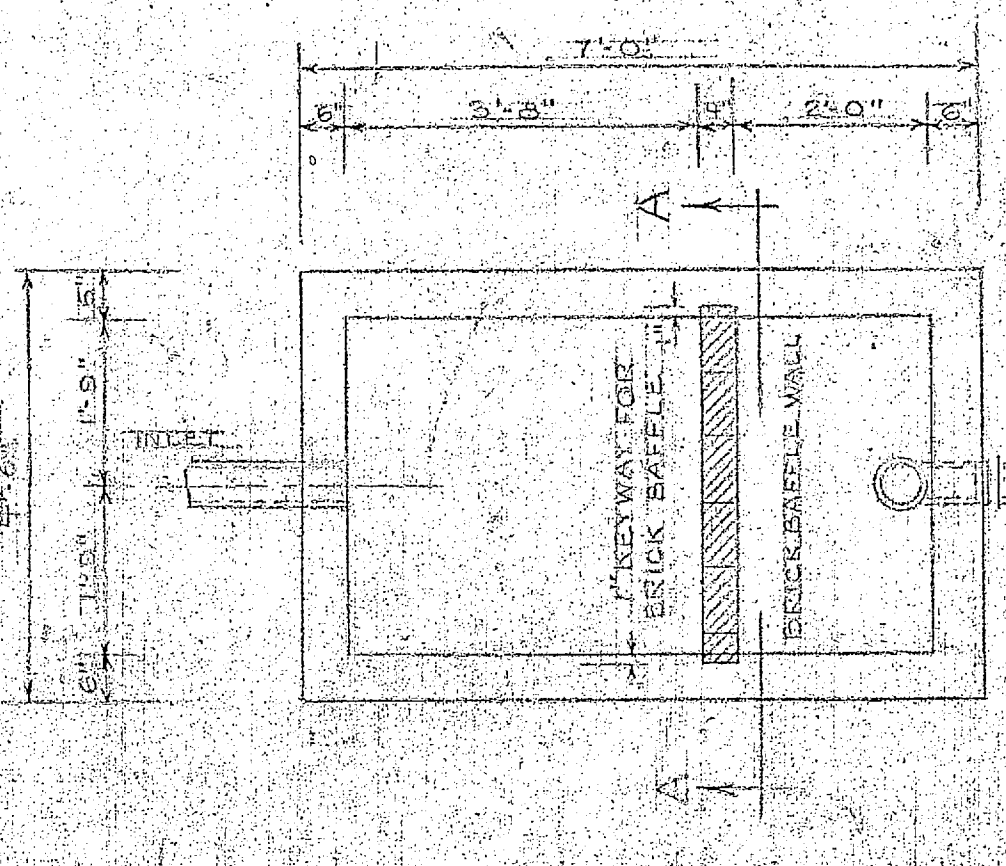

PLAN OF SEPTIC TANK
(COVER REMOVED)
SCALE 1/8" = 1'-0"

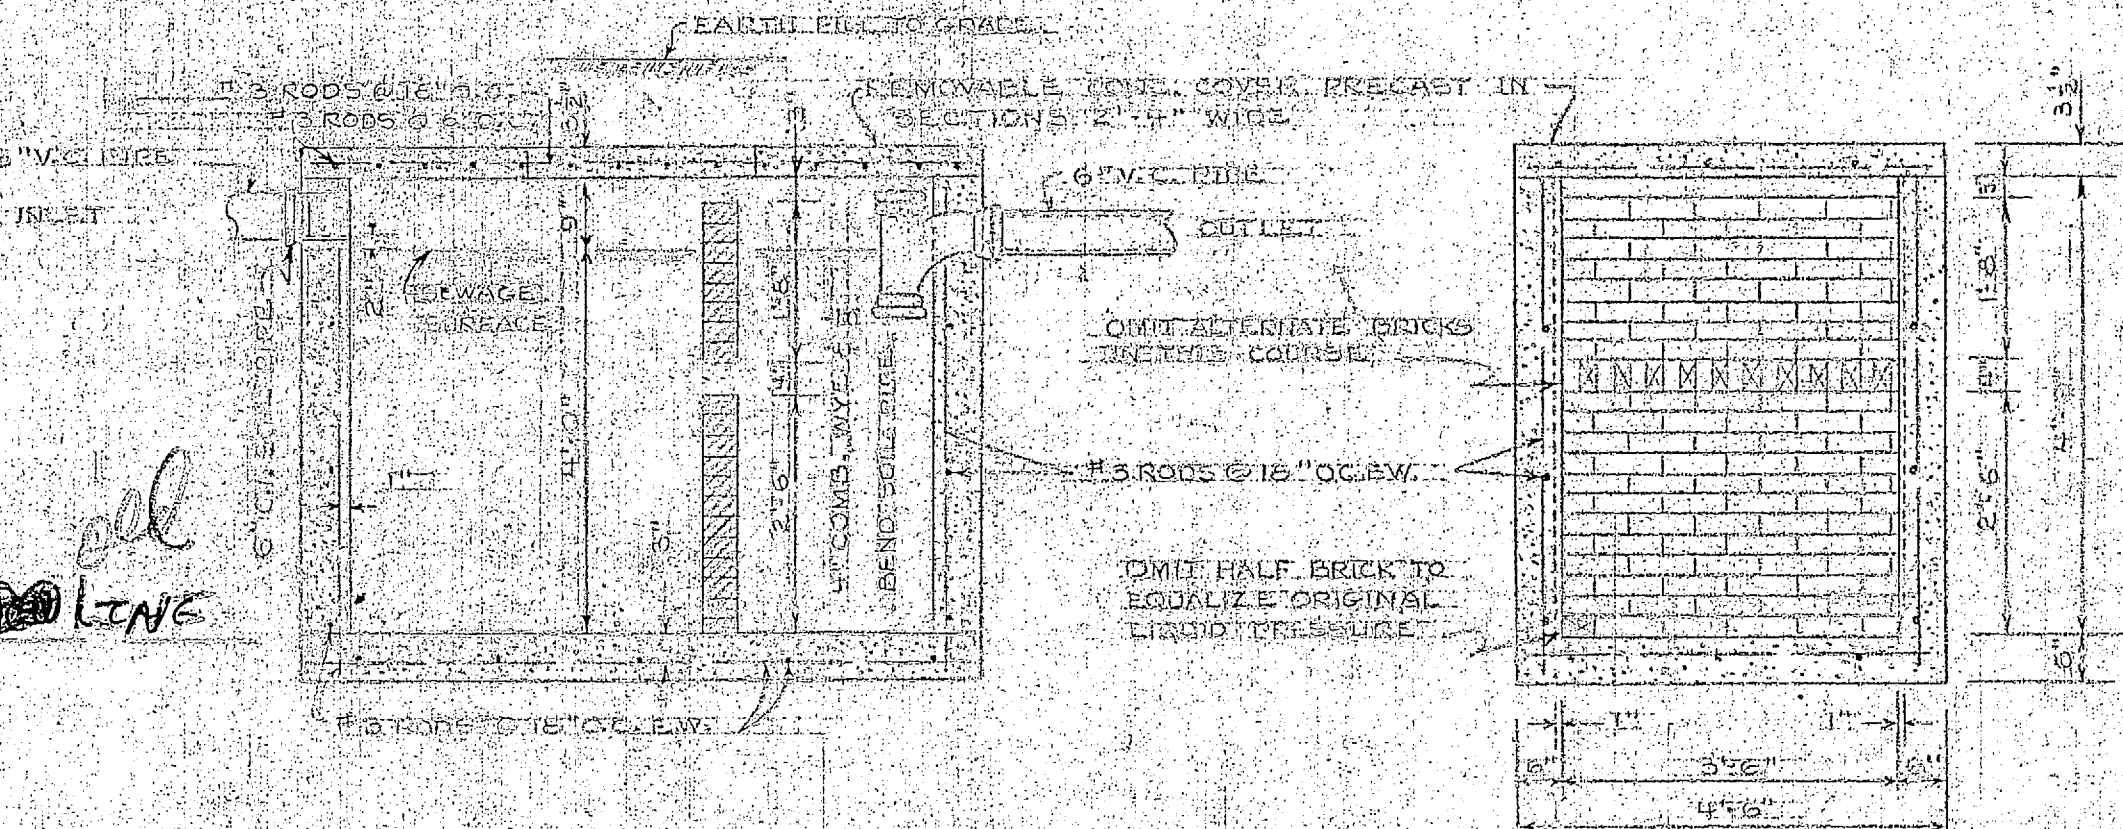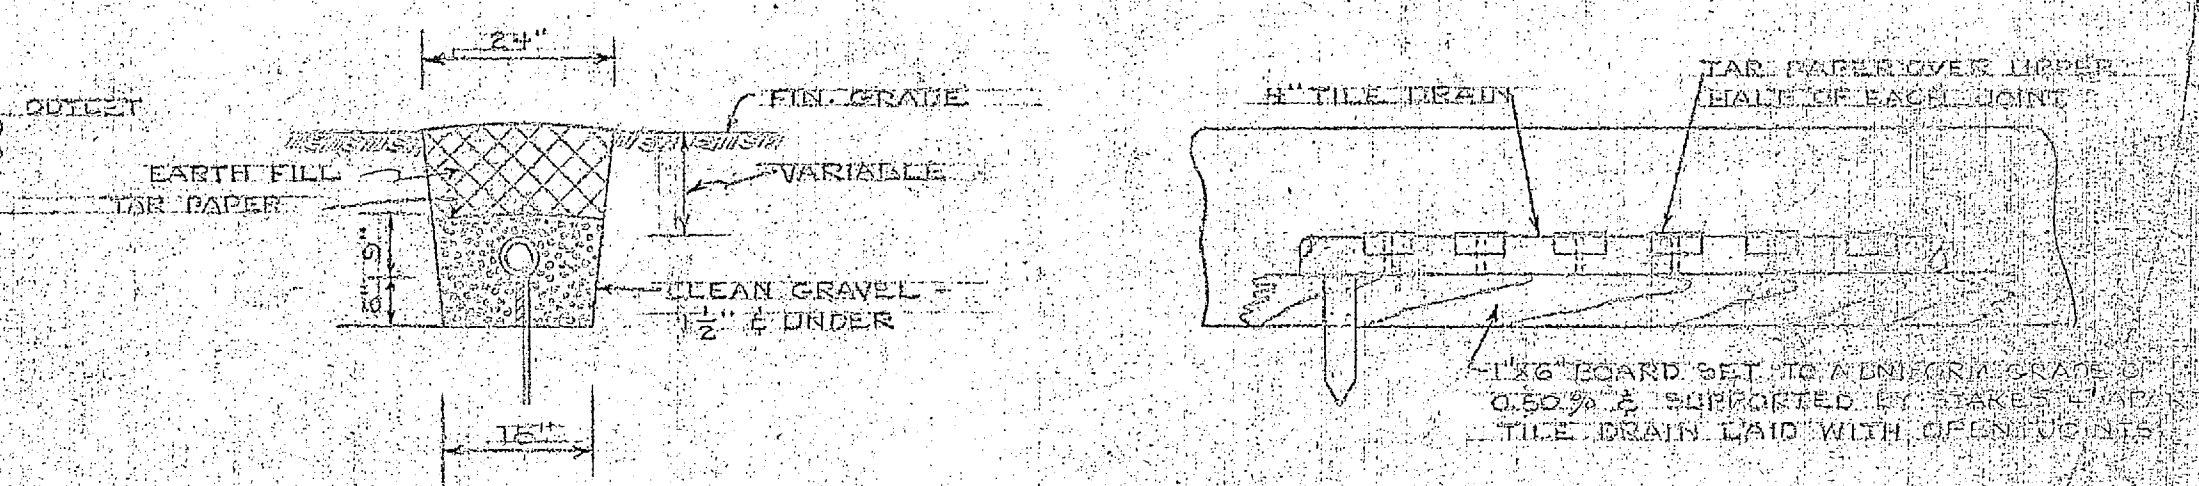

SECTION A-A
SCALE 1/8" = 1'-0"

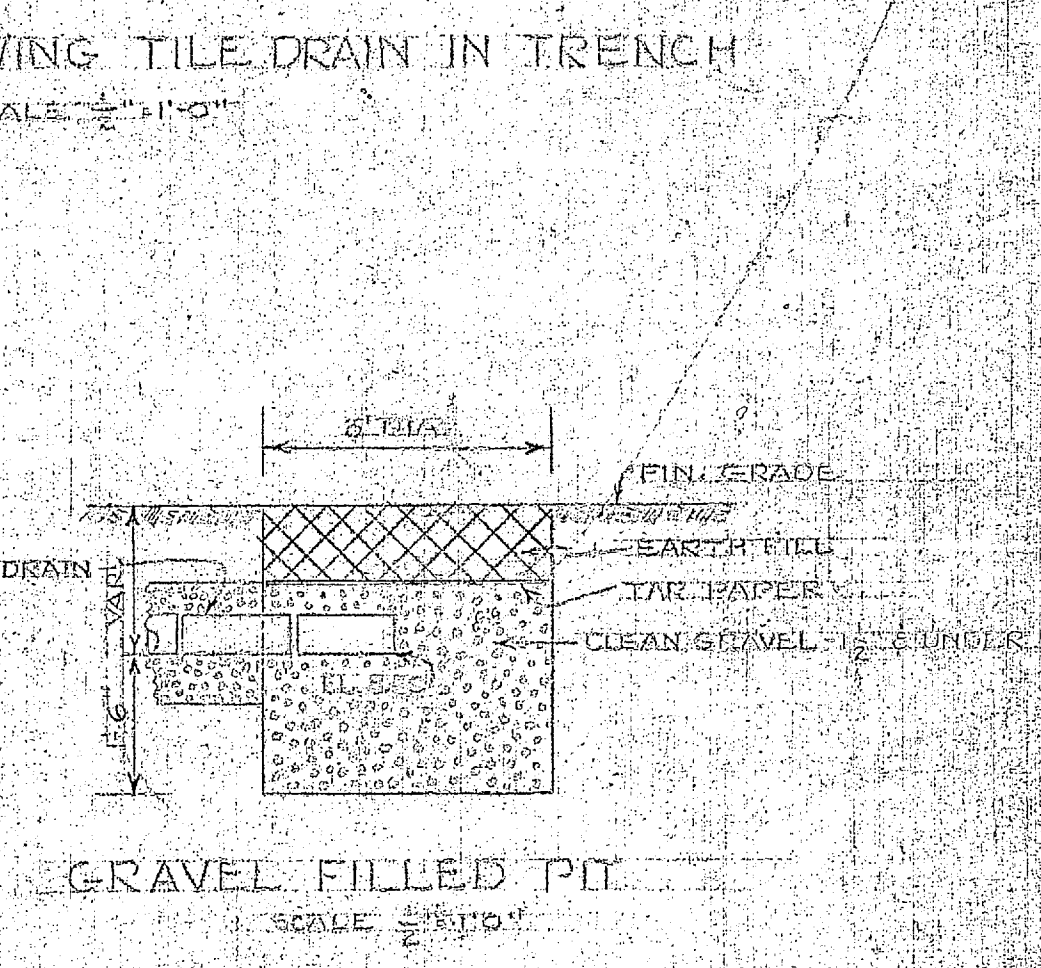

LEGEND

- SAMPLING LINE
- SANITARY SEWER
- STORM DRAINAGE
- TREATED WATER
- 12" CAST IRON PIPE
- 15" CAST IRON PIPE
- 6" STEEL PIPE
- 12" STEEL PIPE
- 15" STEEL PIPE
- 4" SOIL PIPE
- 6" SOIL PIPE
- 8" SOIL PIPE
- 10" SOIL PIPE
- 12" SOIL PIPE
- 15" SOIL PIPE
- 18" SOIL PIPE
- 24" SOIL PIPE
- 30" SOIL PIPE
- 1200" SOIL PIPE

GRAPHIC SCALES



YARD PIPING PLAN
SCALE 1/8" = 1'-0"

SATISFACTORY TO MARINE BASE, CAMP LEJEUNE
COMMANDING GENERAL
DATE: 2 Feb 56

REVISION	DATE	APPD.	AS ORDERED REVISION	BY
PW DRAWING NO. 10532			DESCRIPTION MARINE CORPS BASE CAMP LEJEUNE, N. C.	
DES <i>S.D. Smith</i>			DRAWN <i>S.D. Smith</i>	
CHK <i>S.D. Smith</i>			TR <i>S.D. Smith</i>	
SUPV <i>S.D. Smith</i>			IN CHARGE <i>S.D. Smith</i>	
SATISFACTORY TO THE QUARTERMASTER GENERAL OF THE MARINE CORPS			APPROVED <i>M. Smith</i> DATE <i>2 Feb 56</i>	
DATE			APPROVED FOR BUREAU OF YARDS & DOCKS SCALE: GRAPHIC SPEC 49928	
DATE			DPWO FOR CHIEF OF BUREAU SHEET 4 OF 17 No. 93544 Y & D DRAWING NO 646732	

