



REVISIONS		
NO.	DESCRIPTION	DATE
1	ADD CHANGES TO MECHANICAL PLAN	11/21/57
2	REVISE MECHANICAL PLAN	11/21/57

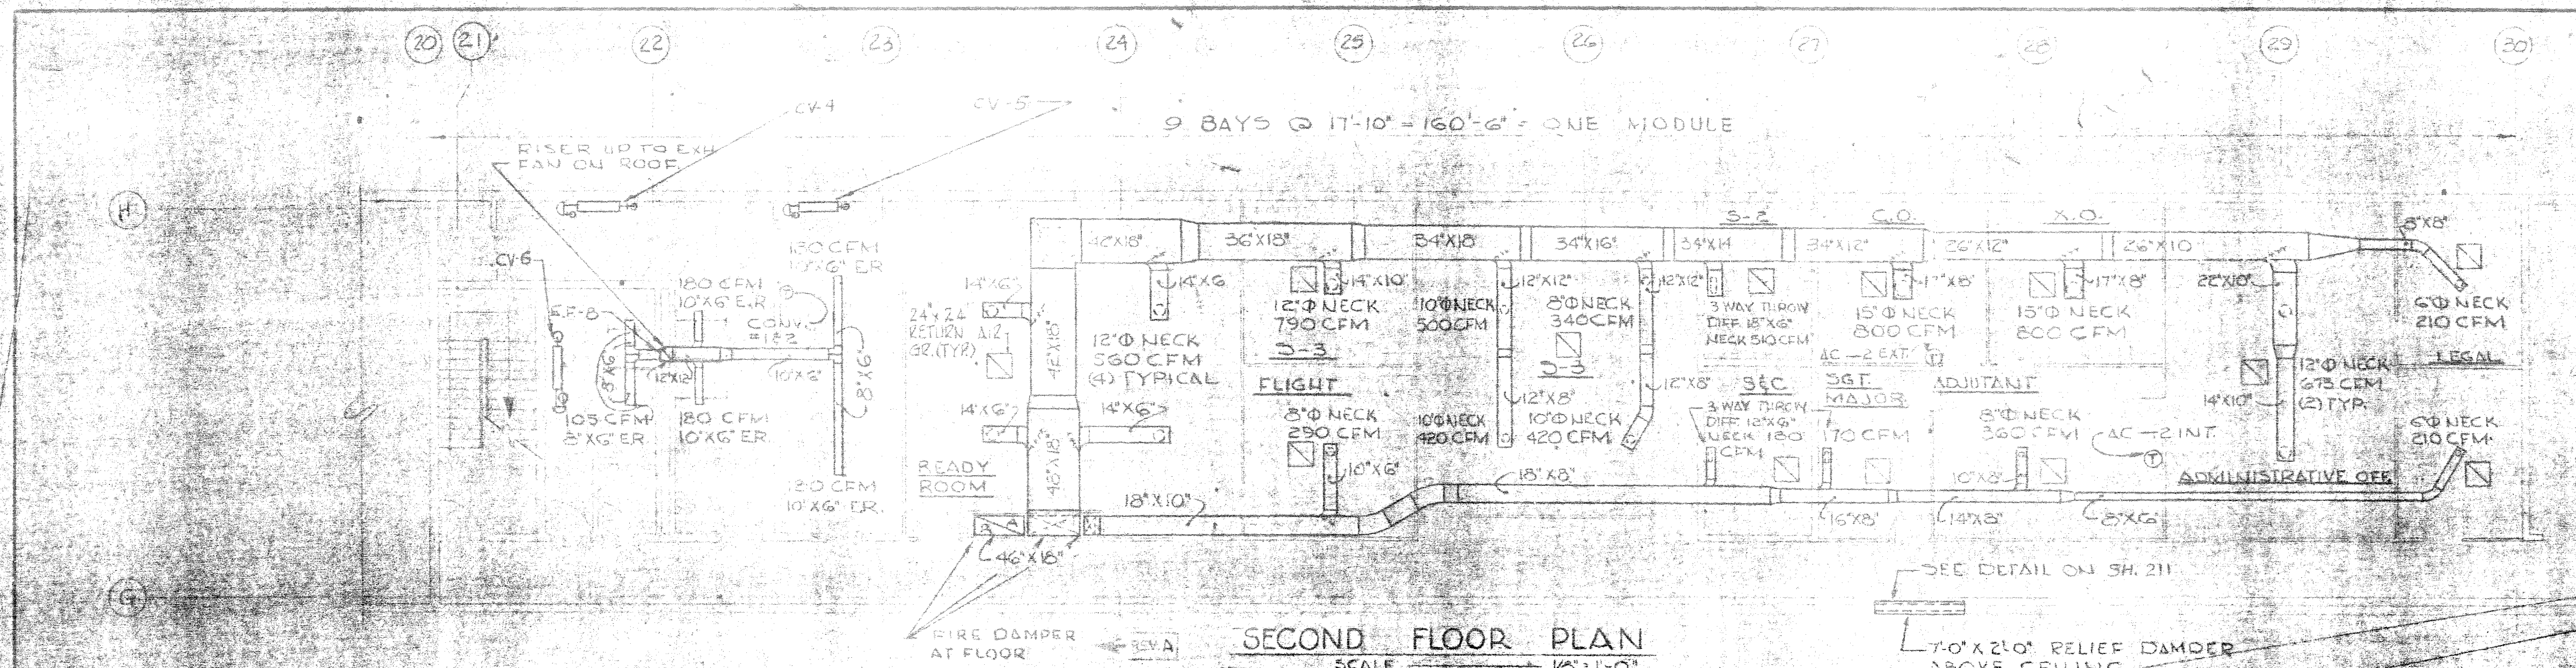


NOTE:
CEILING DIFF. UNLESS OTHERWISE NOTED WILL BE ROUND, NECK SIZES AS SHOWN.




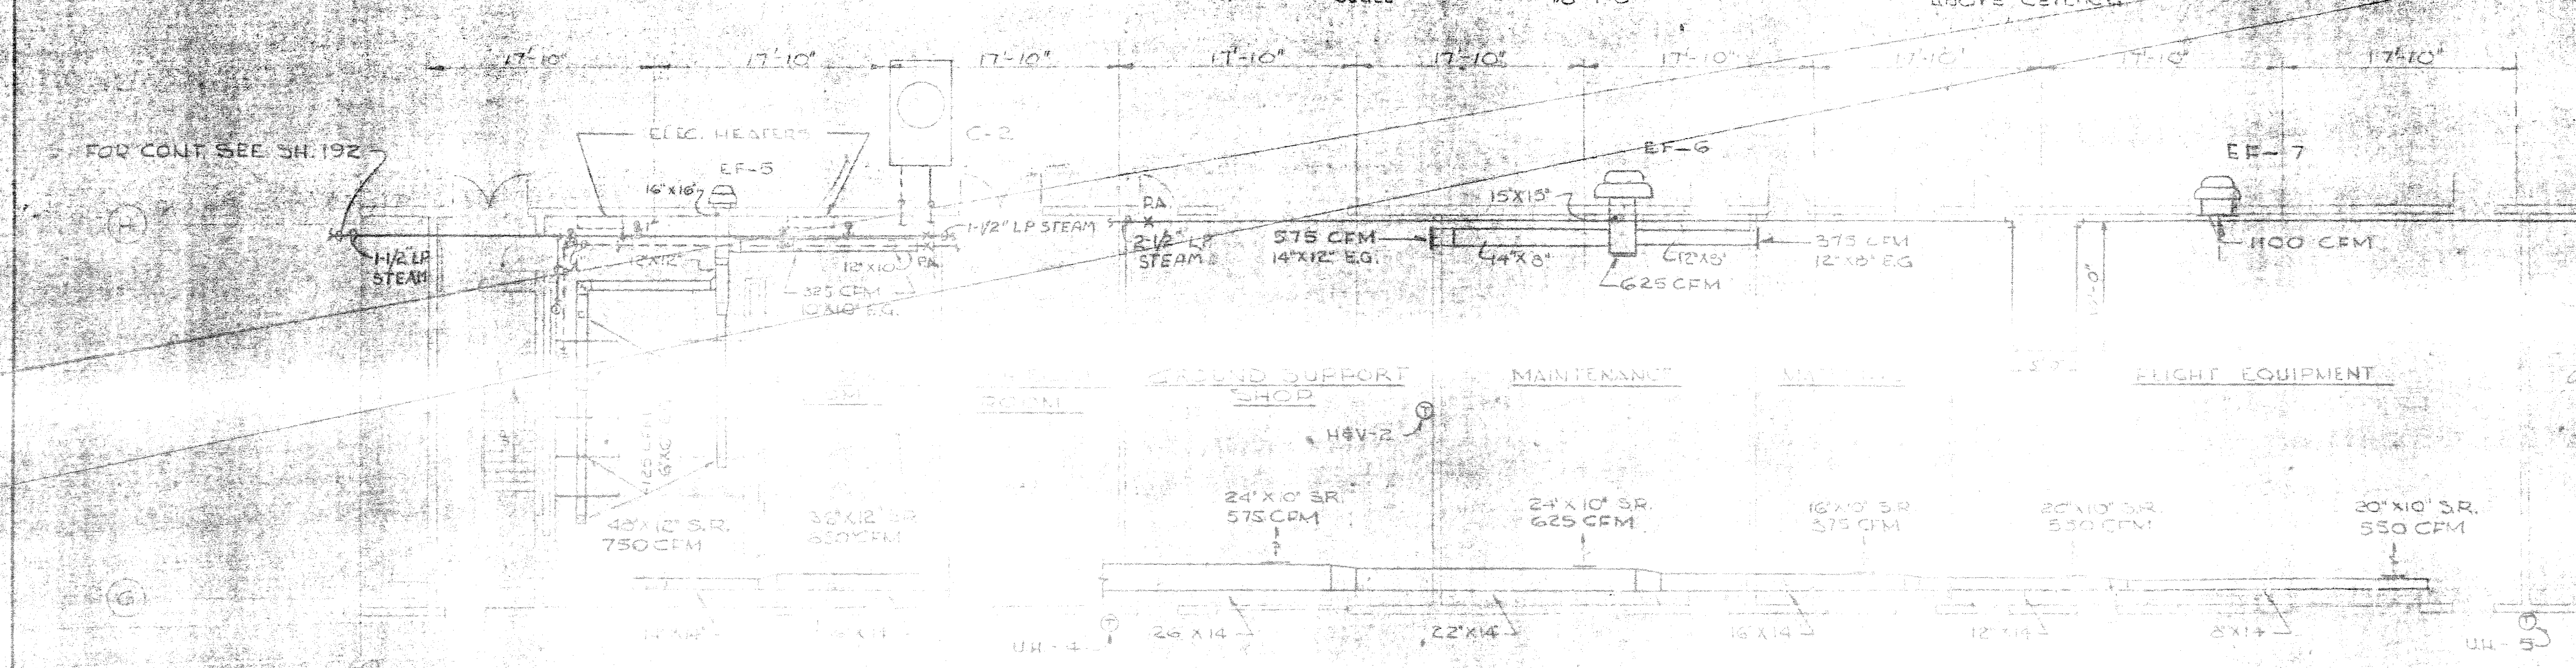


NOTE:
ALL EXH. GRILLES COVERED EXH. UNIT INTAKES

NOTE:
FOR STEAM CONV. EXH. FAN & UNIT INTAKES UNIT & UNIT HEV UNIT & UNIT HEAT EX. SCHEDULE SEE SH. 197

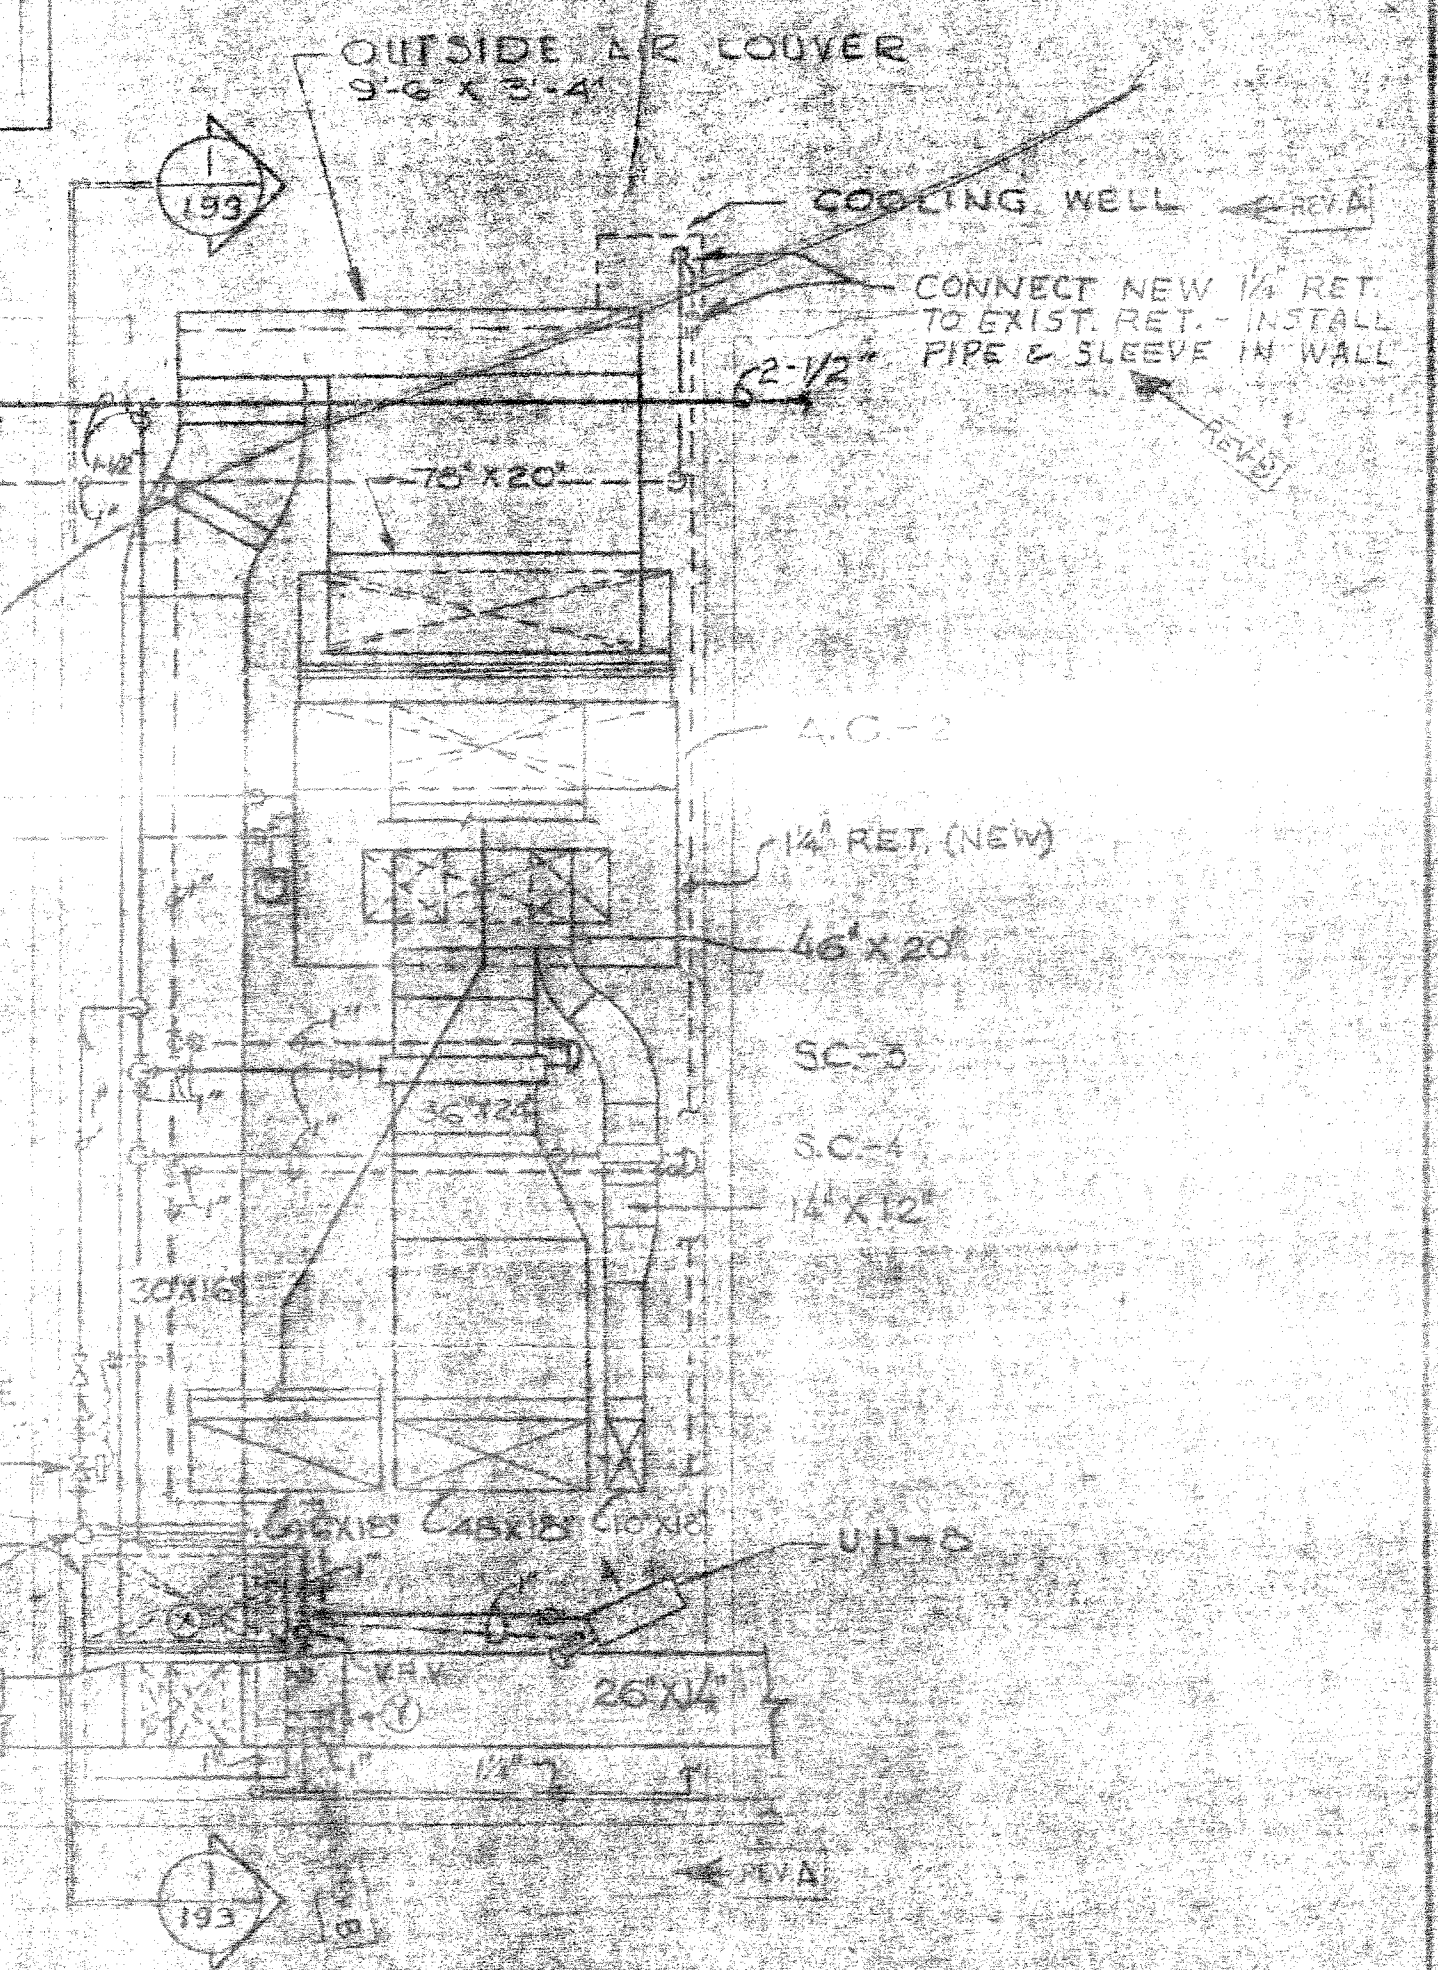

PROVIDE FIRE DAMPER IN EACH DUCT WHERE DUCT GOES THRU FLOOR.

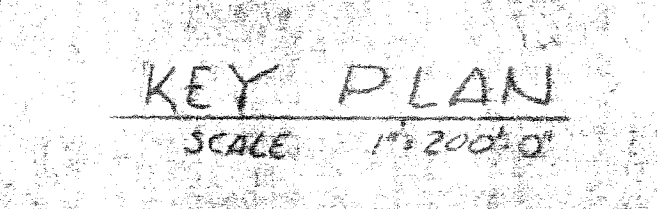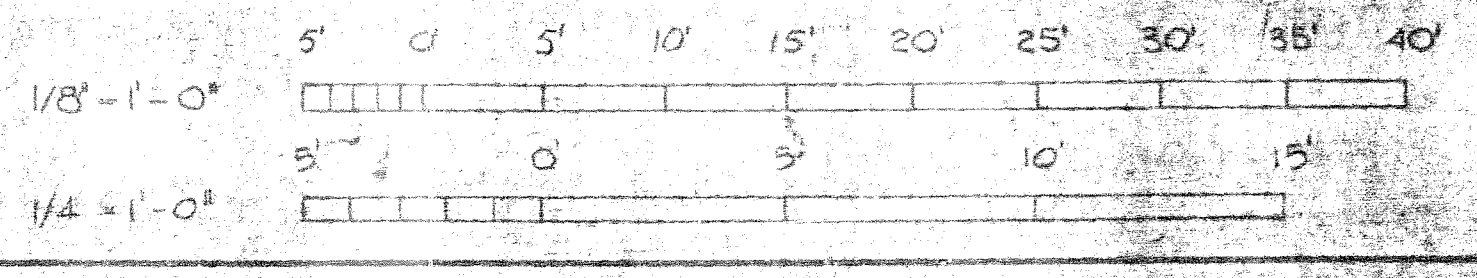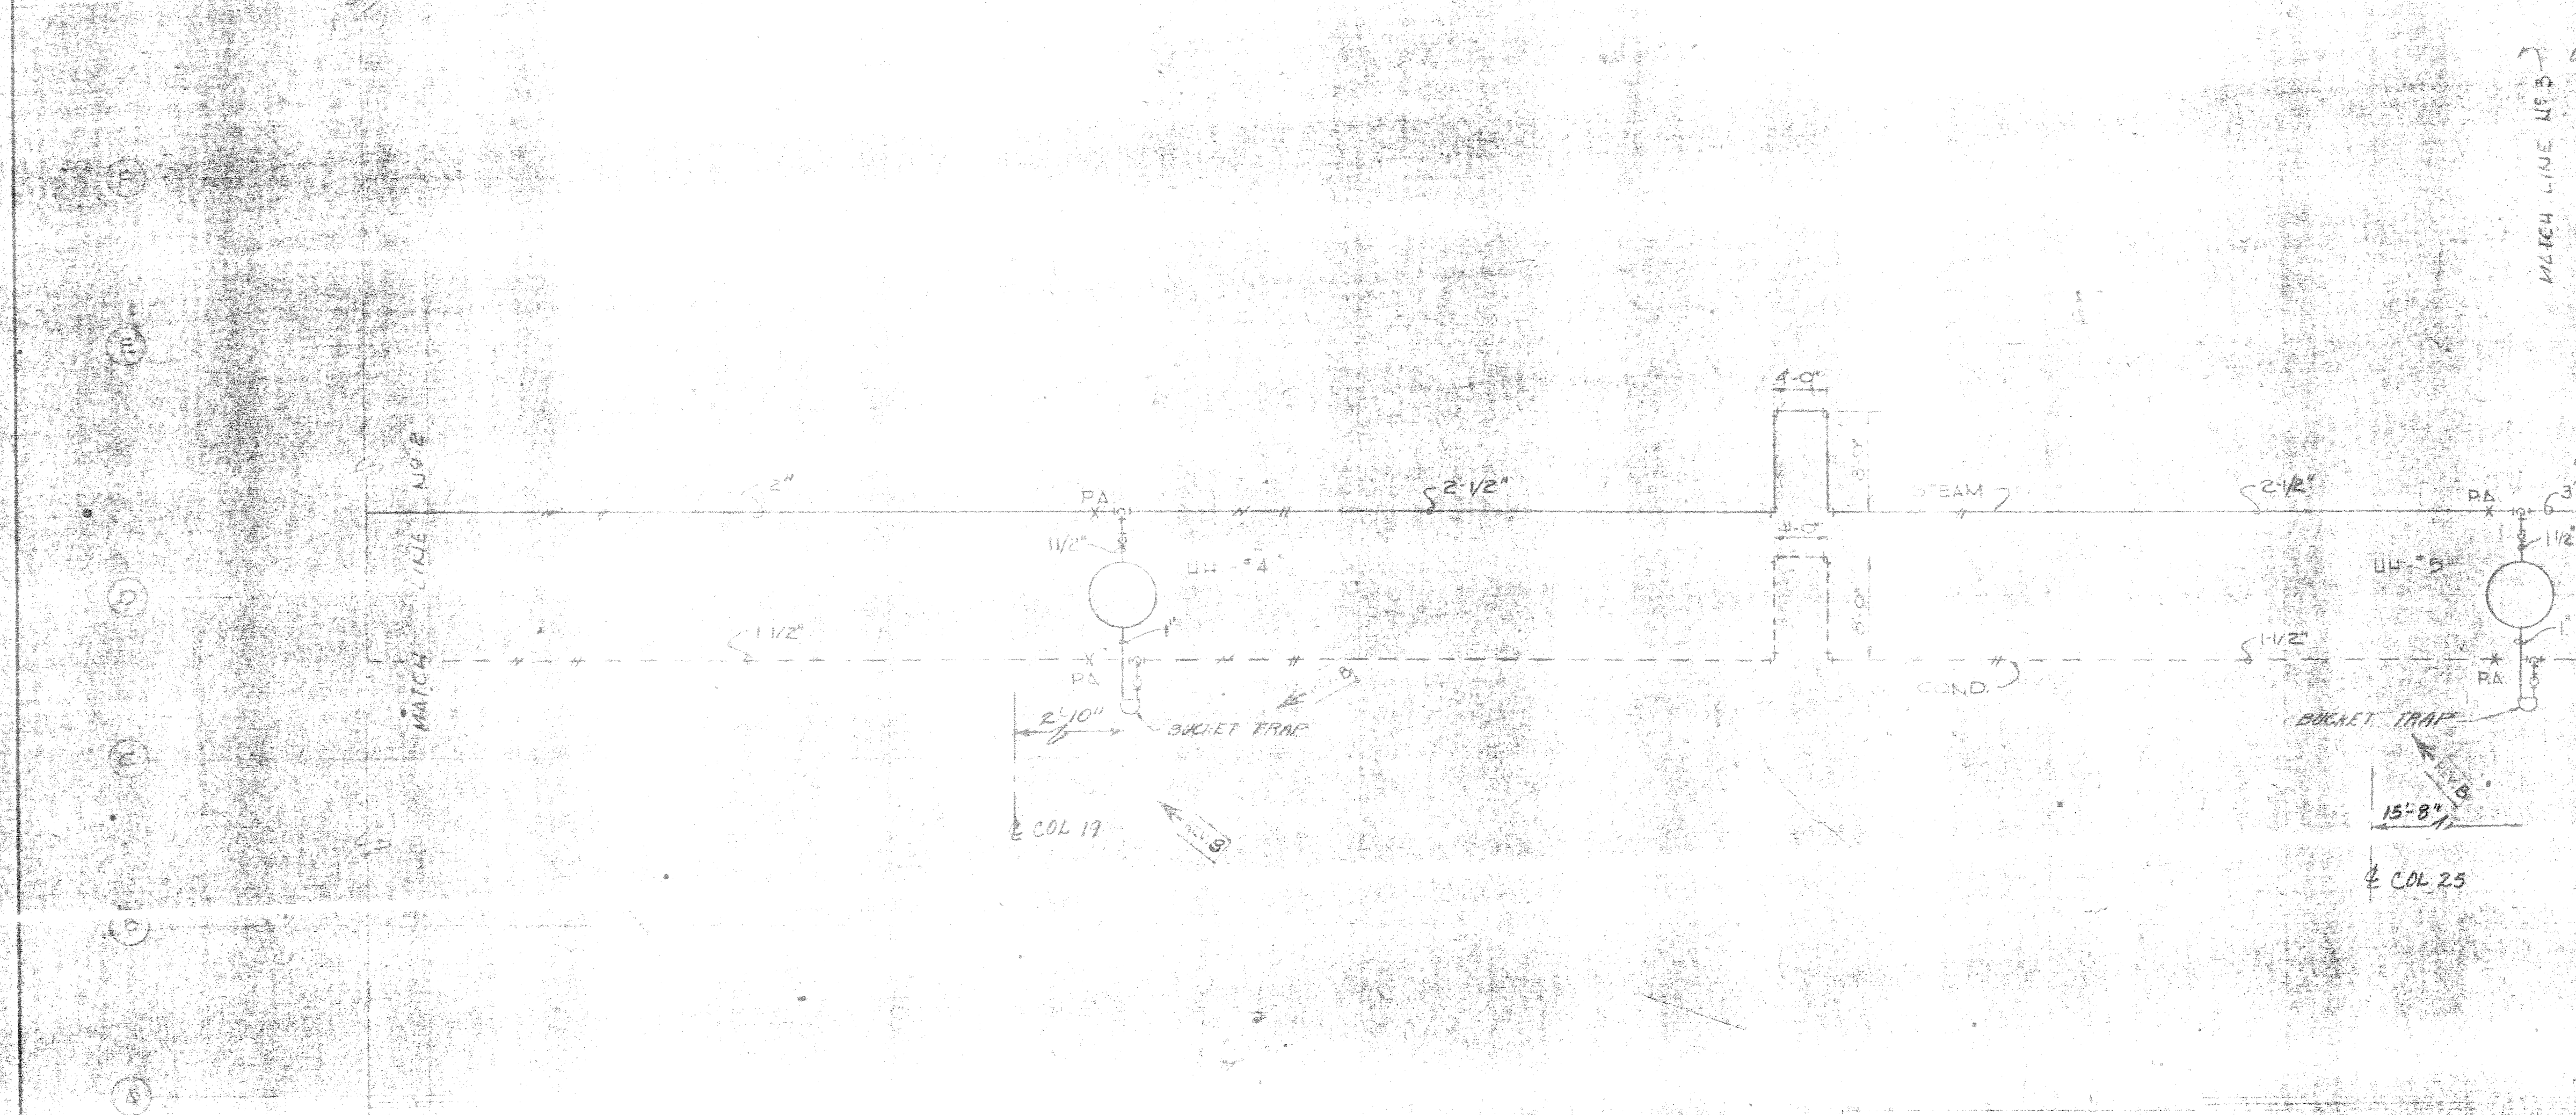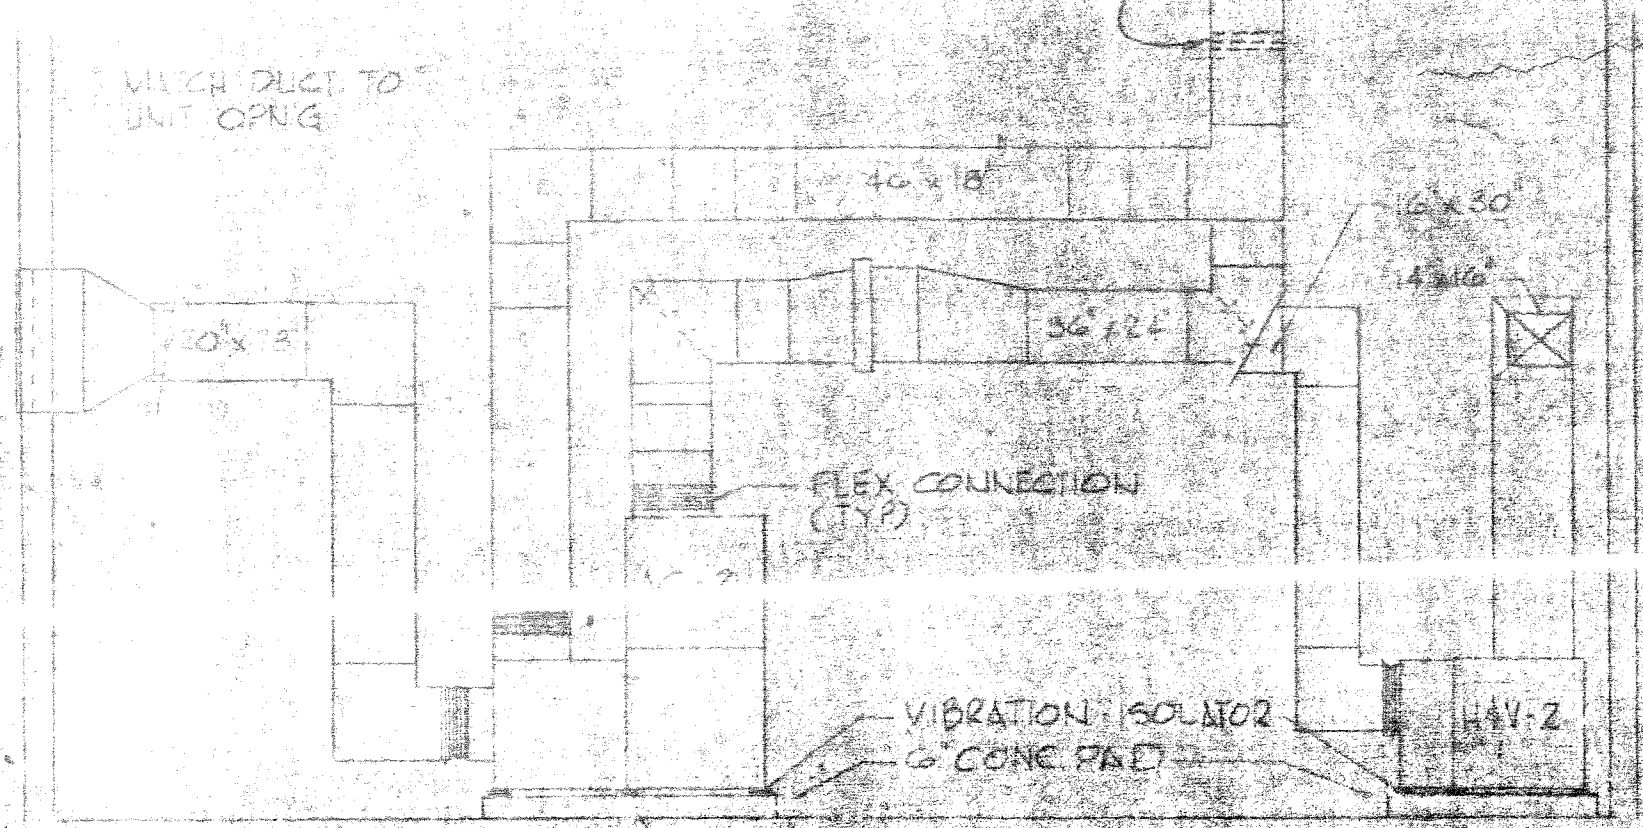

RECORDED DRAWING
DATE FEB 21 1958

LOCKWOOD GREENE ENGINEERS SPARTANBURG, S.C. 29301 ARCHITECTS & ENGINEERS	DEPARTMENT OF THE NAVY NAVAL STATION ATLANTIC DIVISION NAVAIR VAWB NAVAIR VAWB NAVAIR VAWB
DESIGNED BY: [Signature] CHECKED BY: [Signature] DRAWN BY: [Signature] DATE: 11/21/57	PROJECT: AC HEAT & VENT. PLAN & DETAILS ORGANIZATION: ORGANIZATIONAL MAINTENANCE HANGAR LOCATION: NCAF - NEW RIVER, JACKSONVILLE, N.C. DRAWING NO.: 110374
APPROVED: [Signature] DATE: 11/21/57	SCALE: AS SHOWN

